


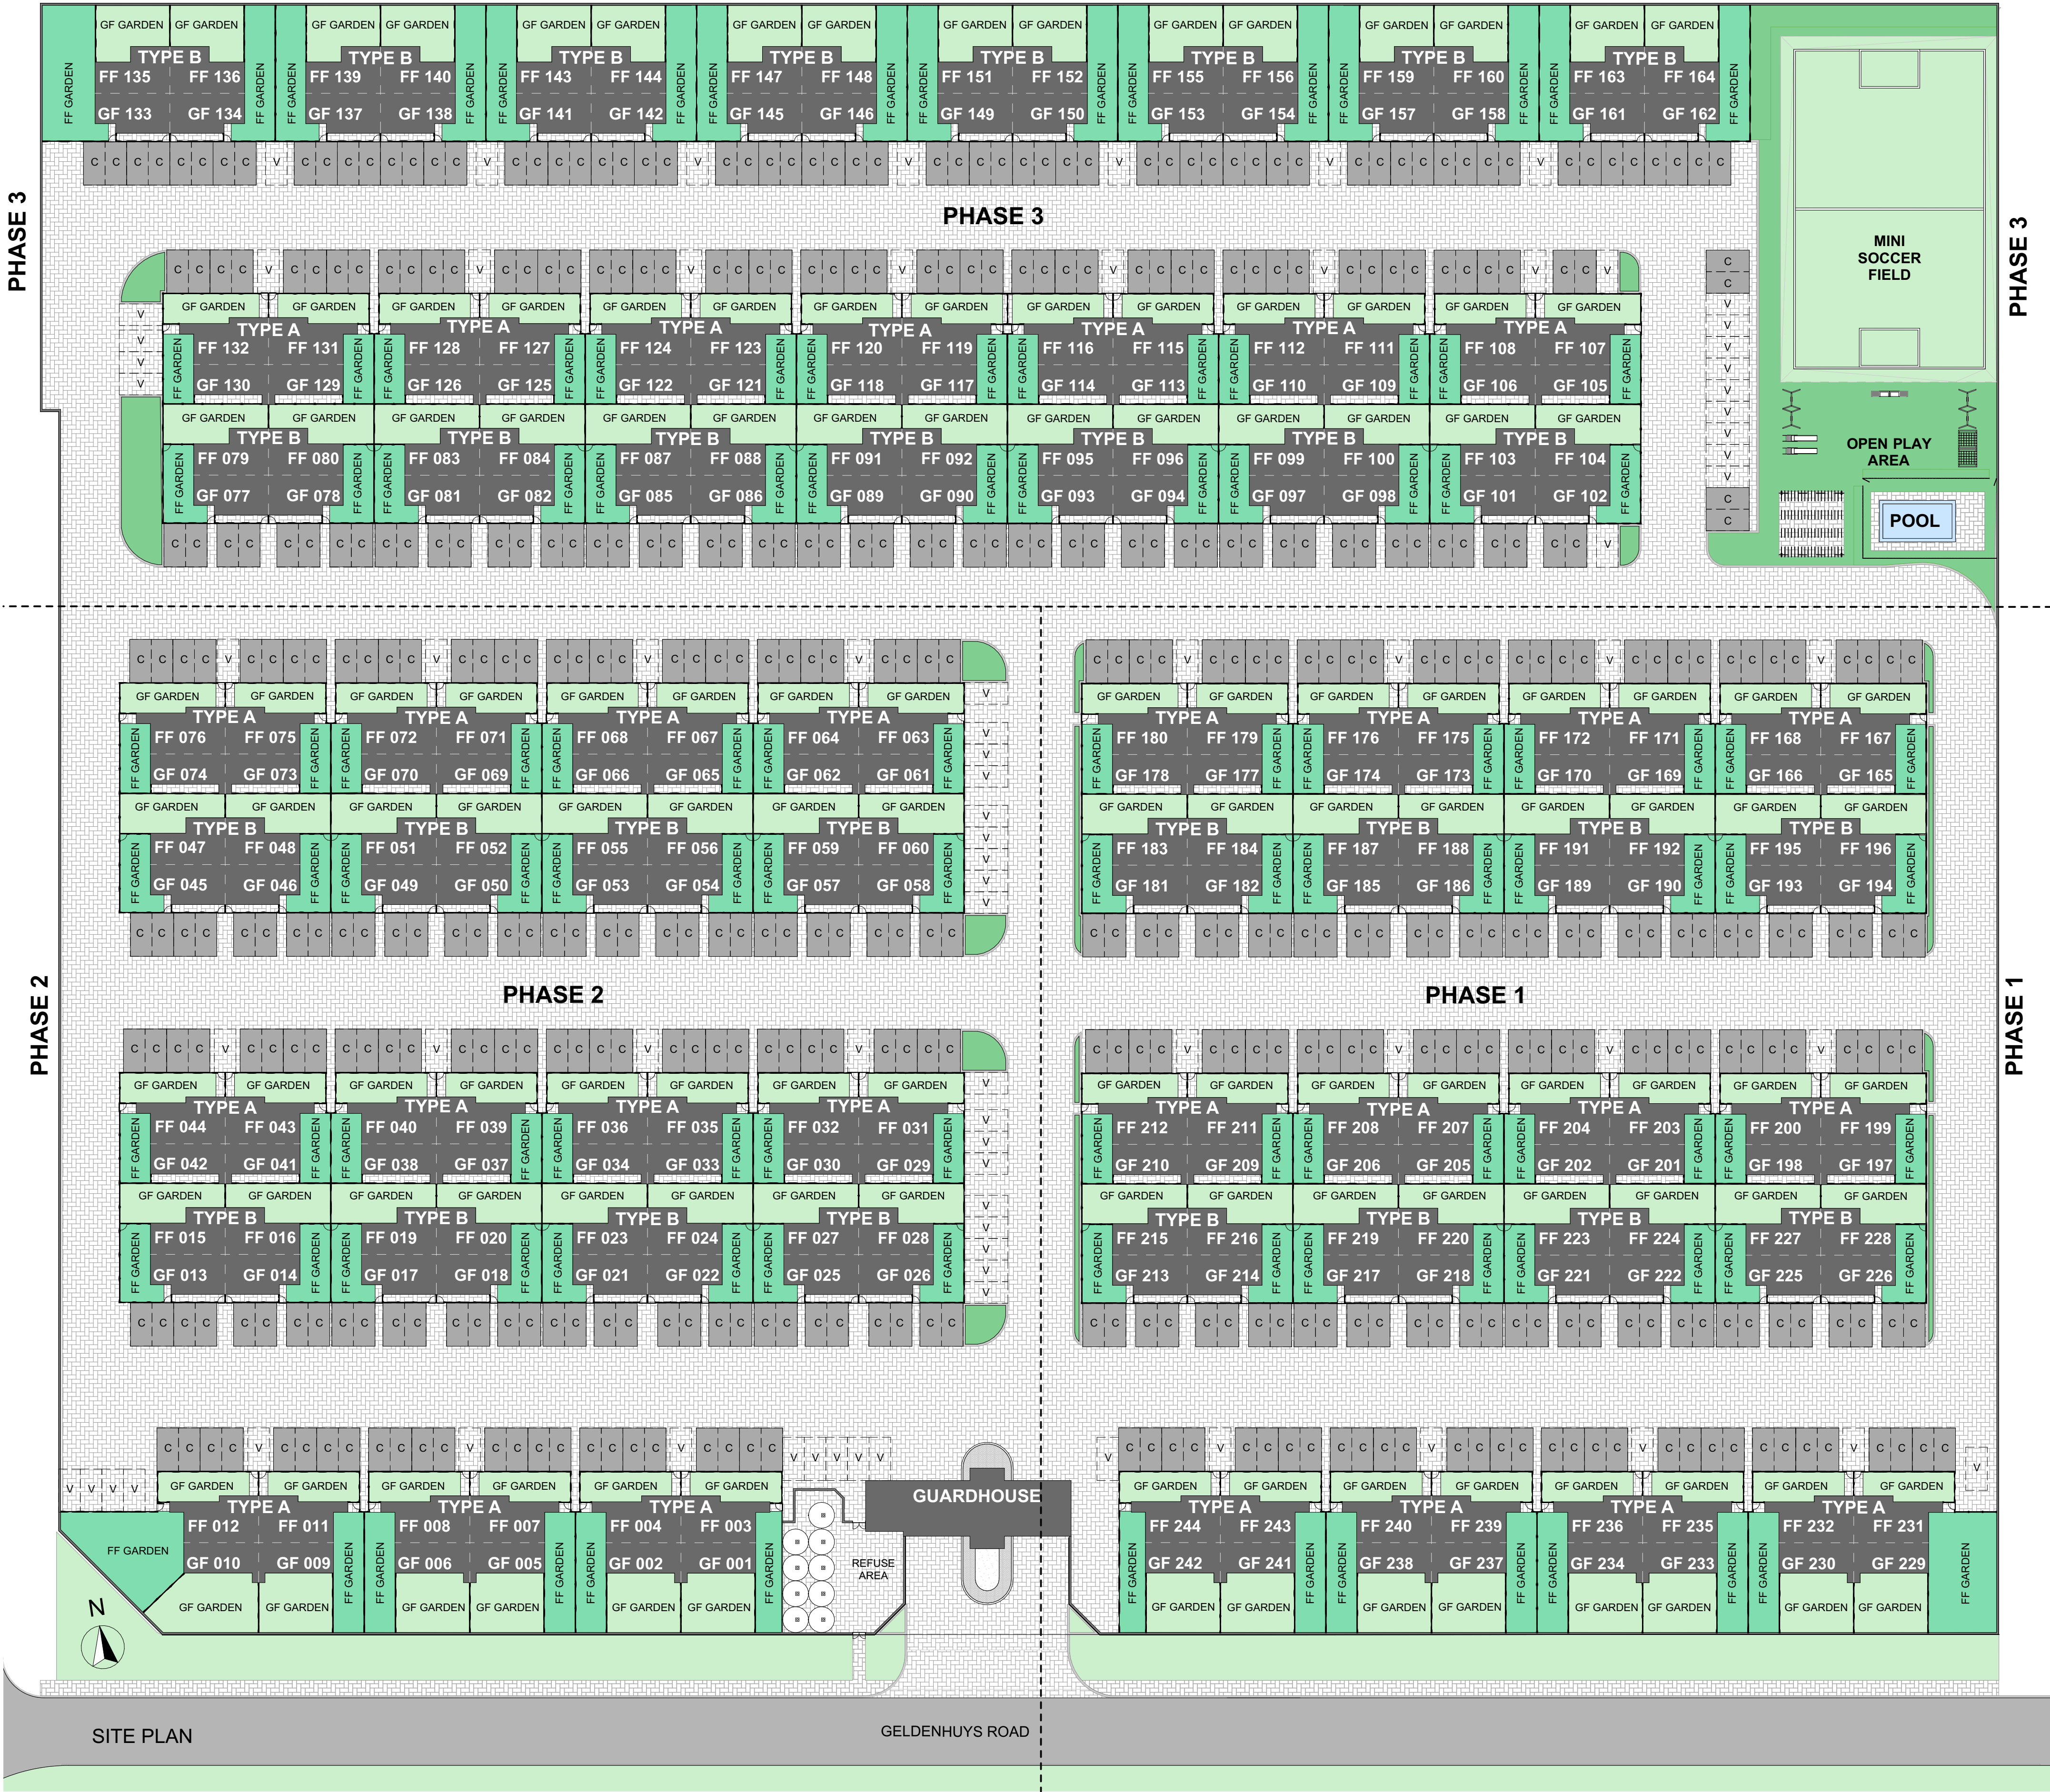


SSI
Group



VANRICK
ARCHITECTURE
WWW.VANRICK.CO.ZA


TYPE A - GROUND FLOOR

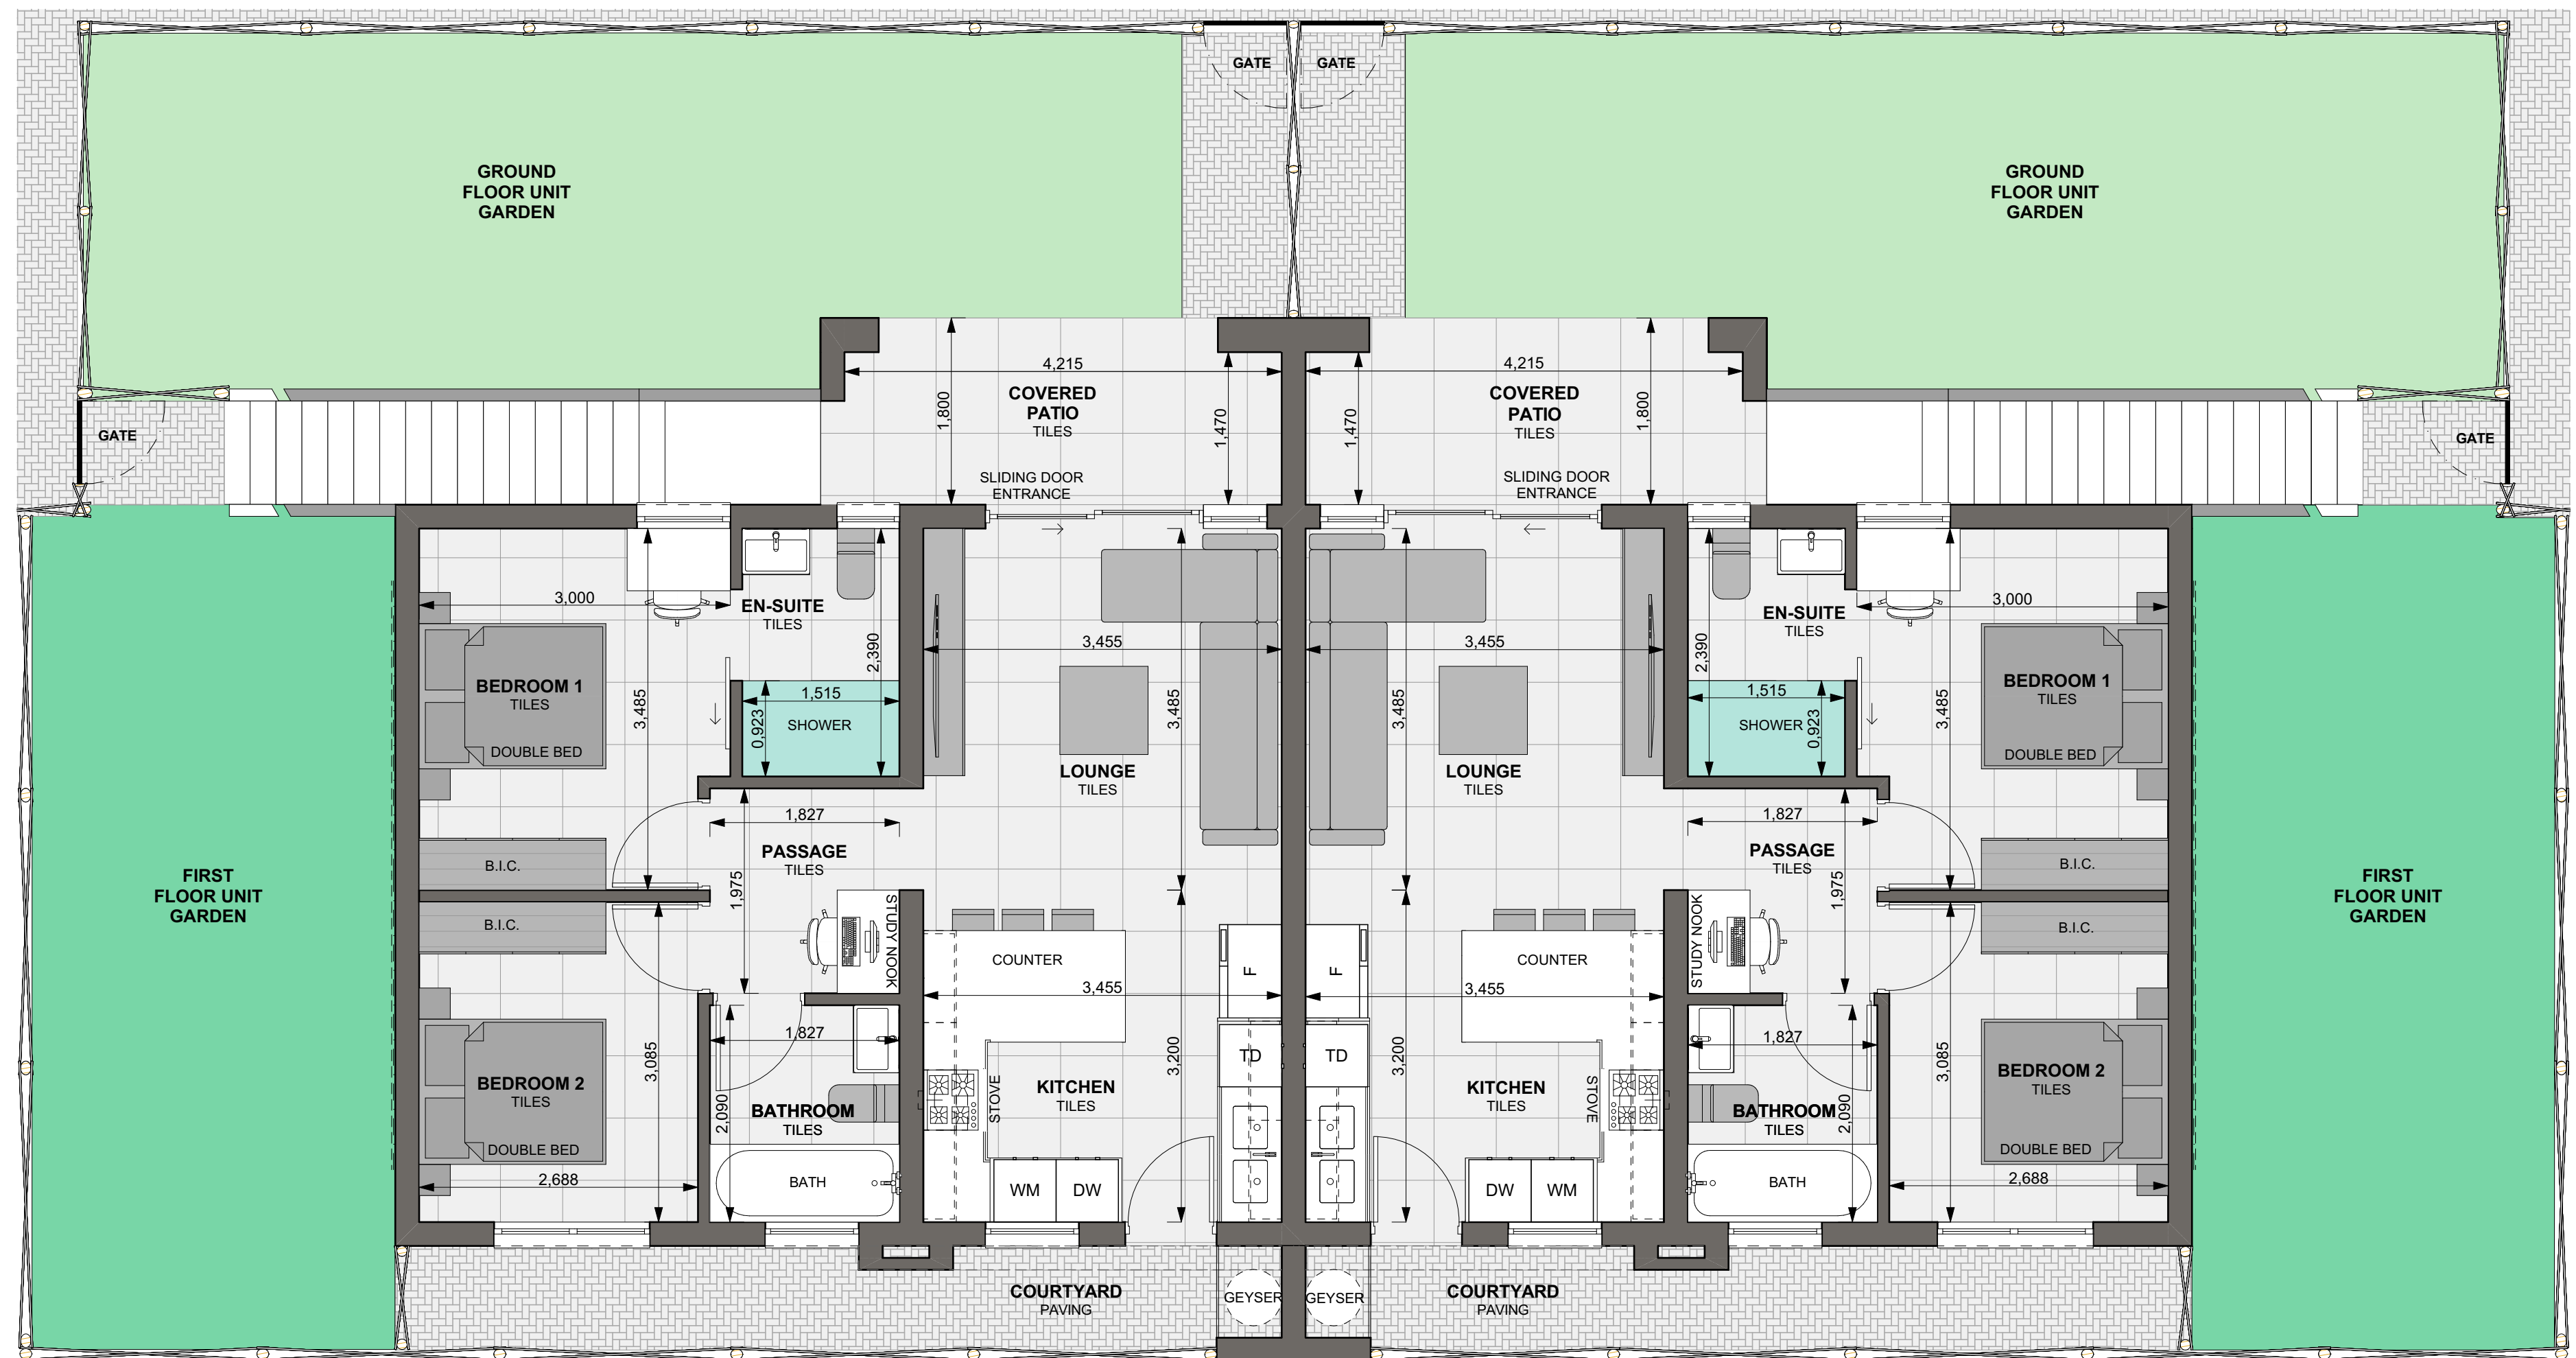

GROUND FLOOR
SCALE 1:50

TYPE A - NORTH ENTRY

GROUND FLOOR: 61,88
PATIO: 8,21
70,09 m²

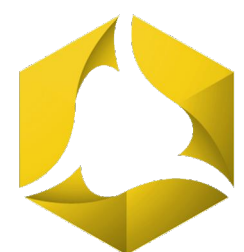


SSI
Group



VANRICK
ARCHITECTURE
WWW.VANRICK.CO.ZA


TYPE A - FIRST FLOOR

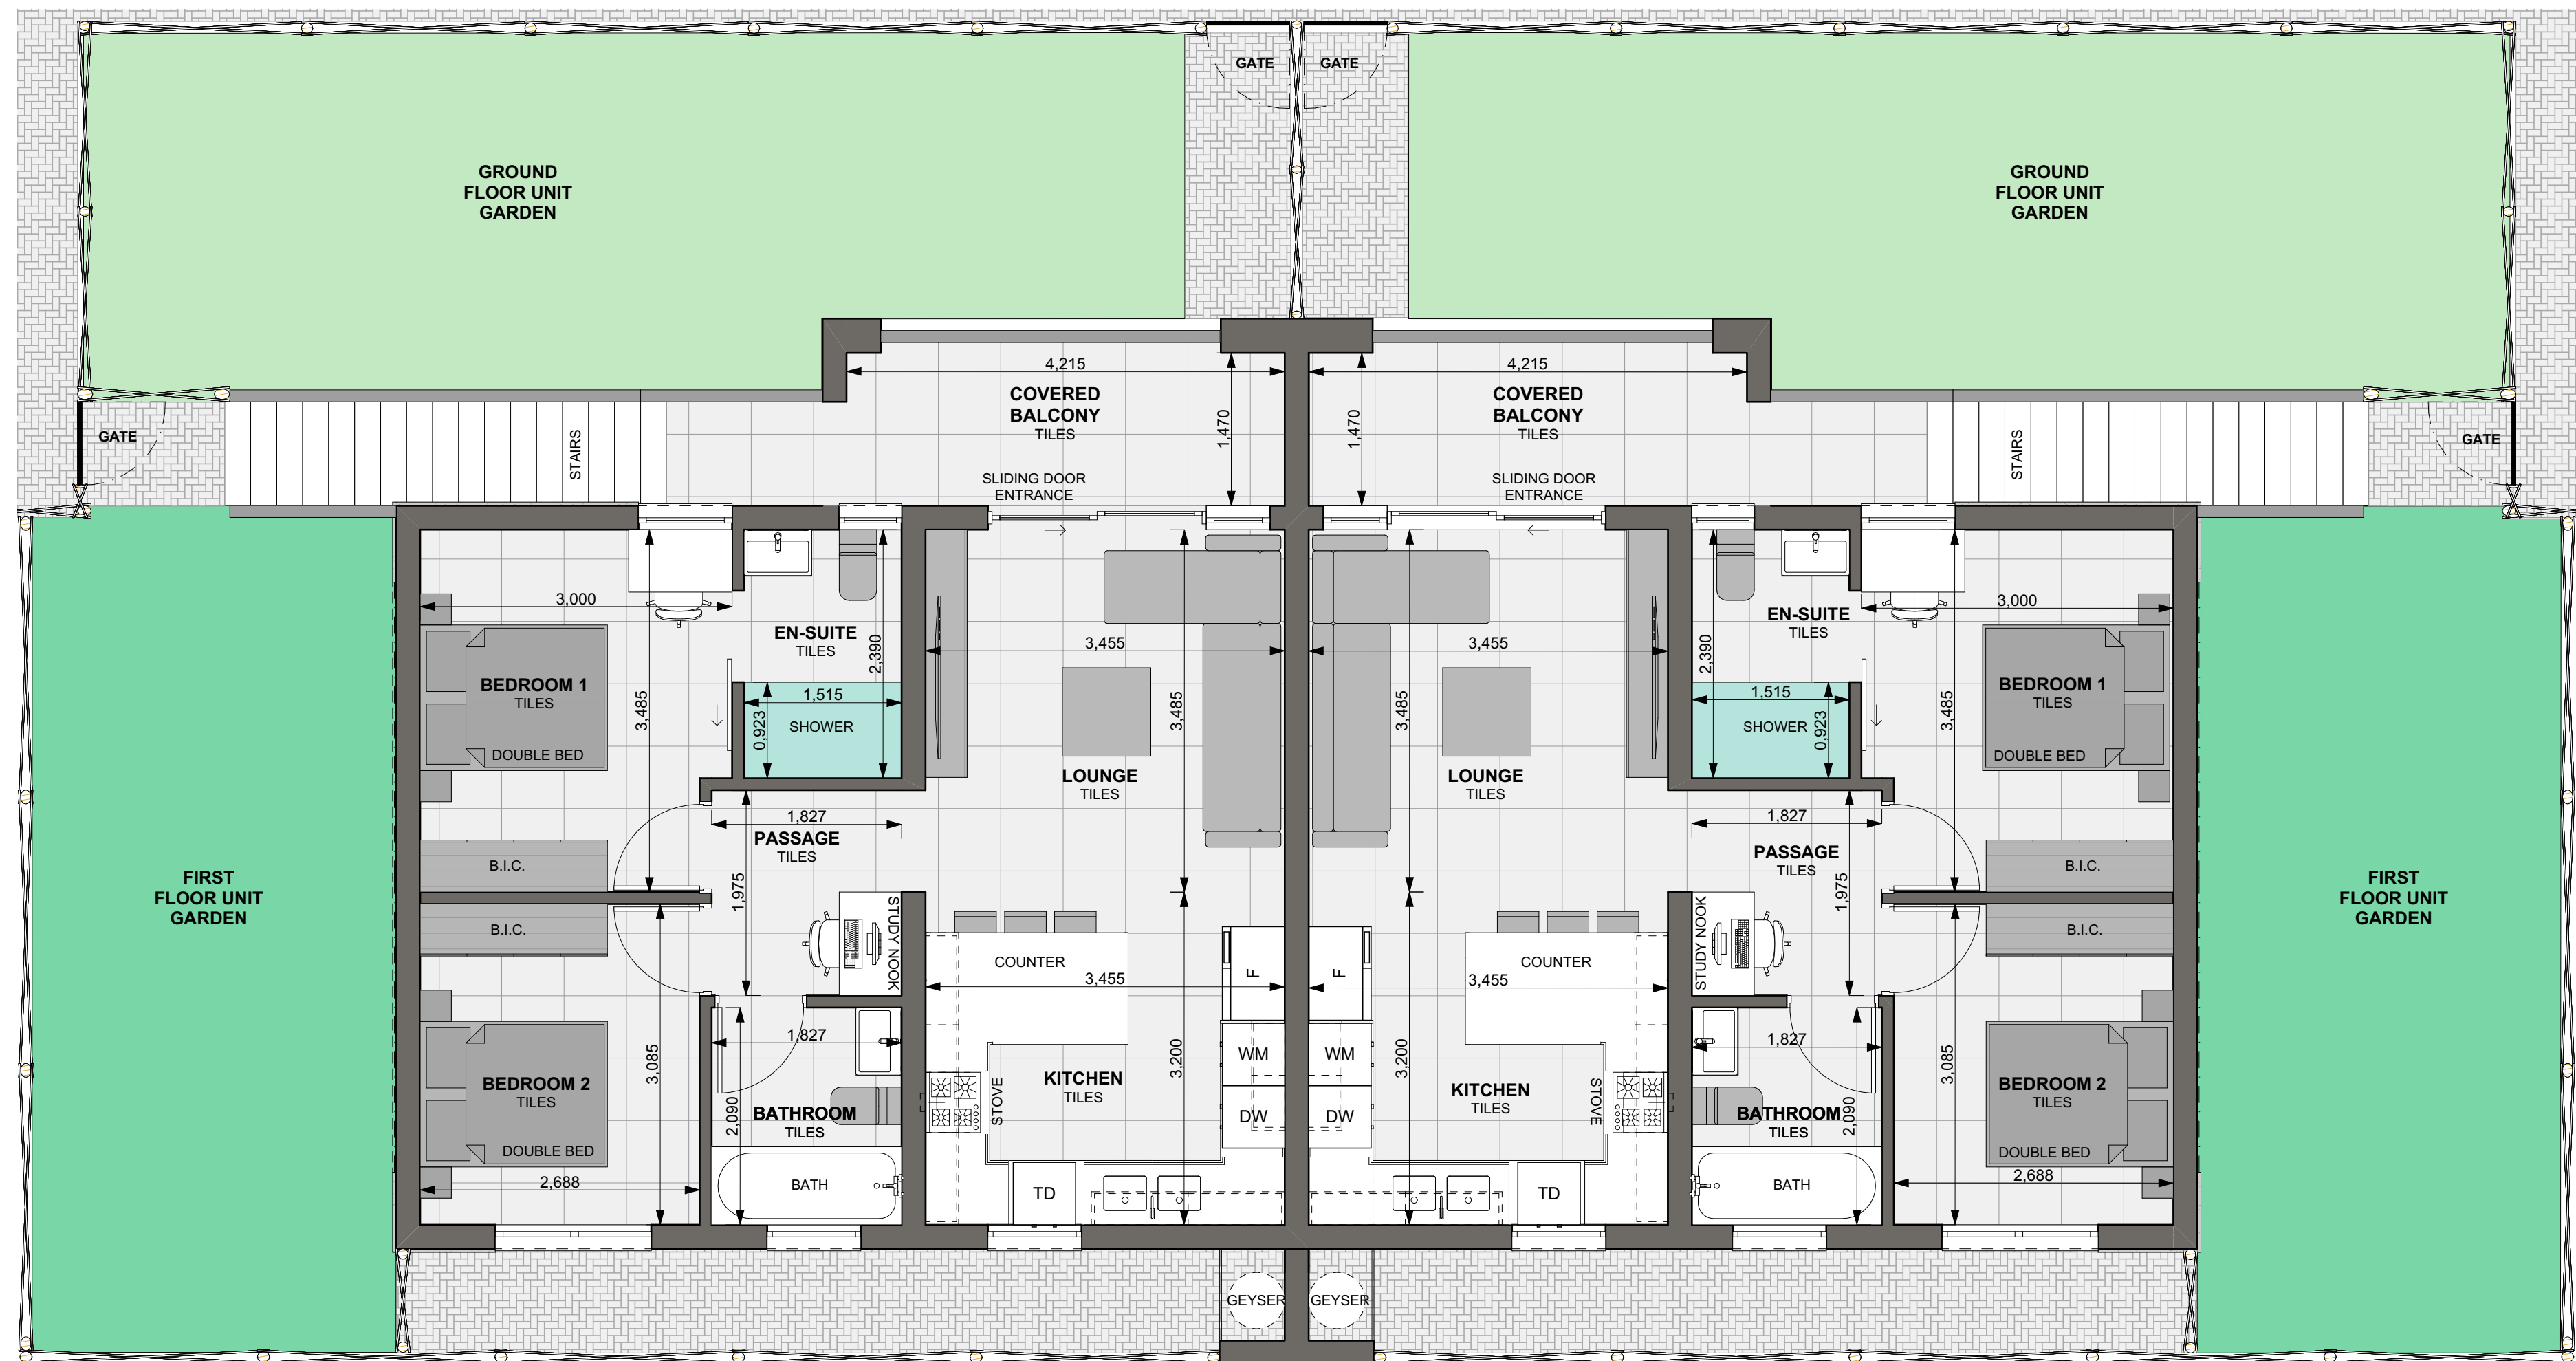

FIRST FLOOR
SCALE 1:50

TYPE A - NORTH ENTRY

FIRST FLOOR: 61,88
BALCONY: 8,21
70,09 m²

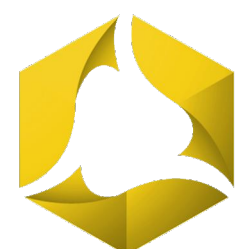

SSI
Group



VANRICK
ARCHITECTURE
WWW.VANRICK.CO.ZA

LEFT GROUND
FLOOR UNIT

RIGHT GROUND
FLOOR UNIT

LEFT
FIRST
FLOOR
GARDEN

RIGHT
FIRST
FLOOR
GARDEN

FIRST
FLOOR
GARDEN
GATE

FIRST
FLOOR
GARDEN
GATE

LEFT
GROUND
FLOOR
GARDEN


RIGHT
GROUND
FLOOR
GARDEN

GROUND
FLOOR
GARDEN
GATE


GROUND
FLOOR
GARDEN
GATE

TYPE A - NORTH ENTRY - GROUND FLOOR




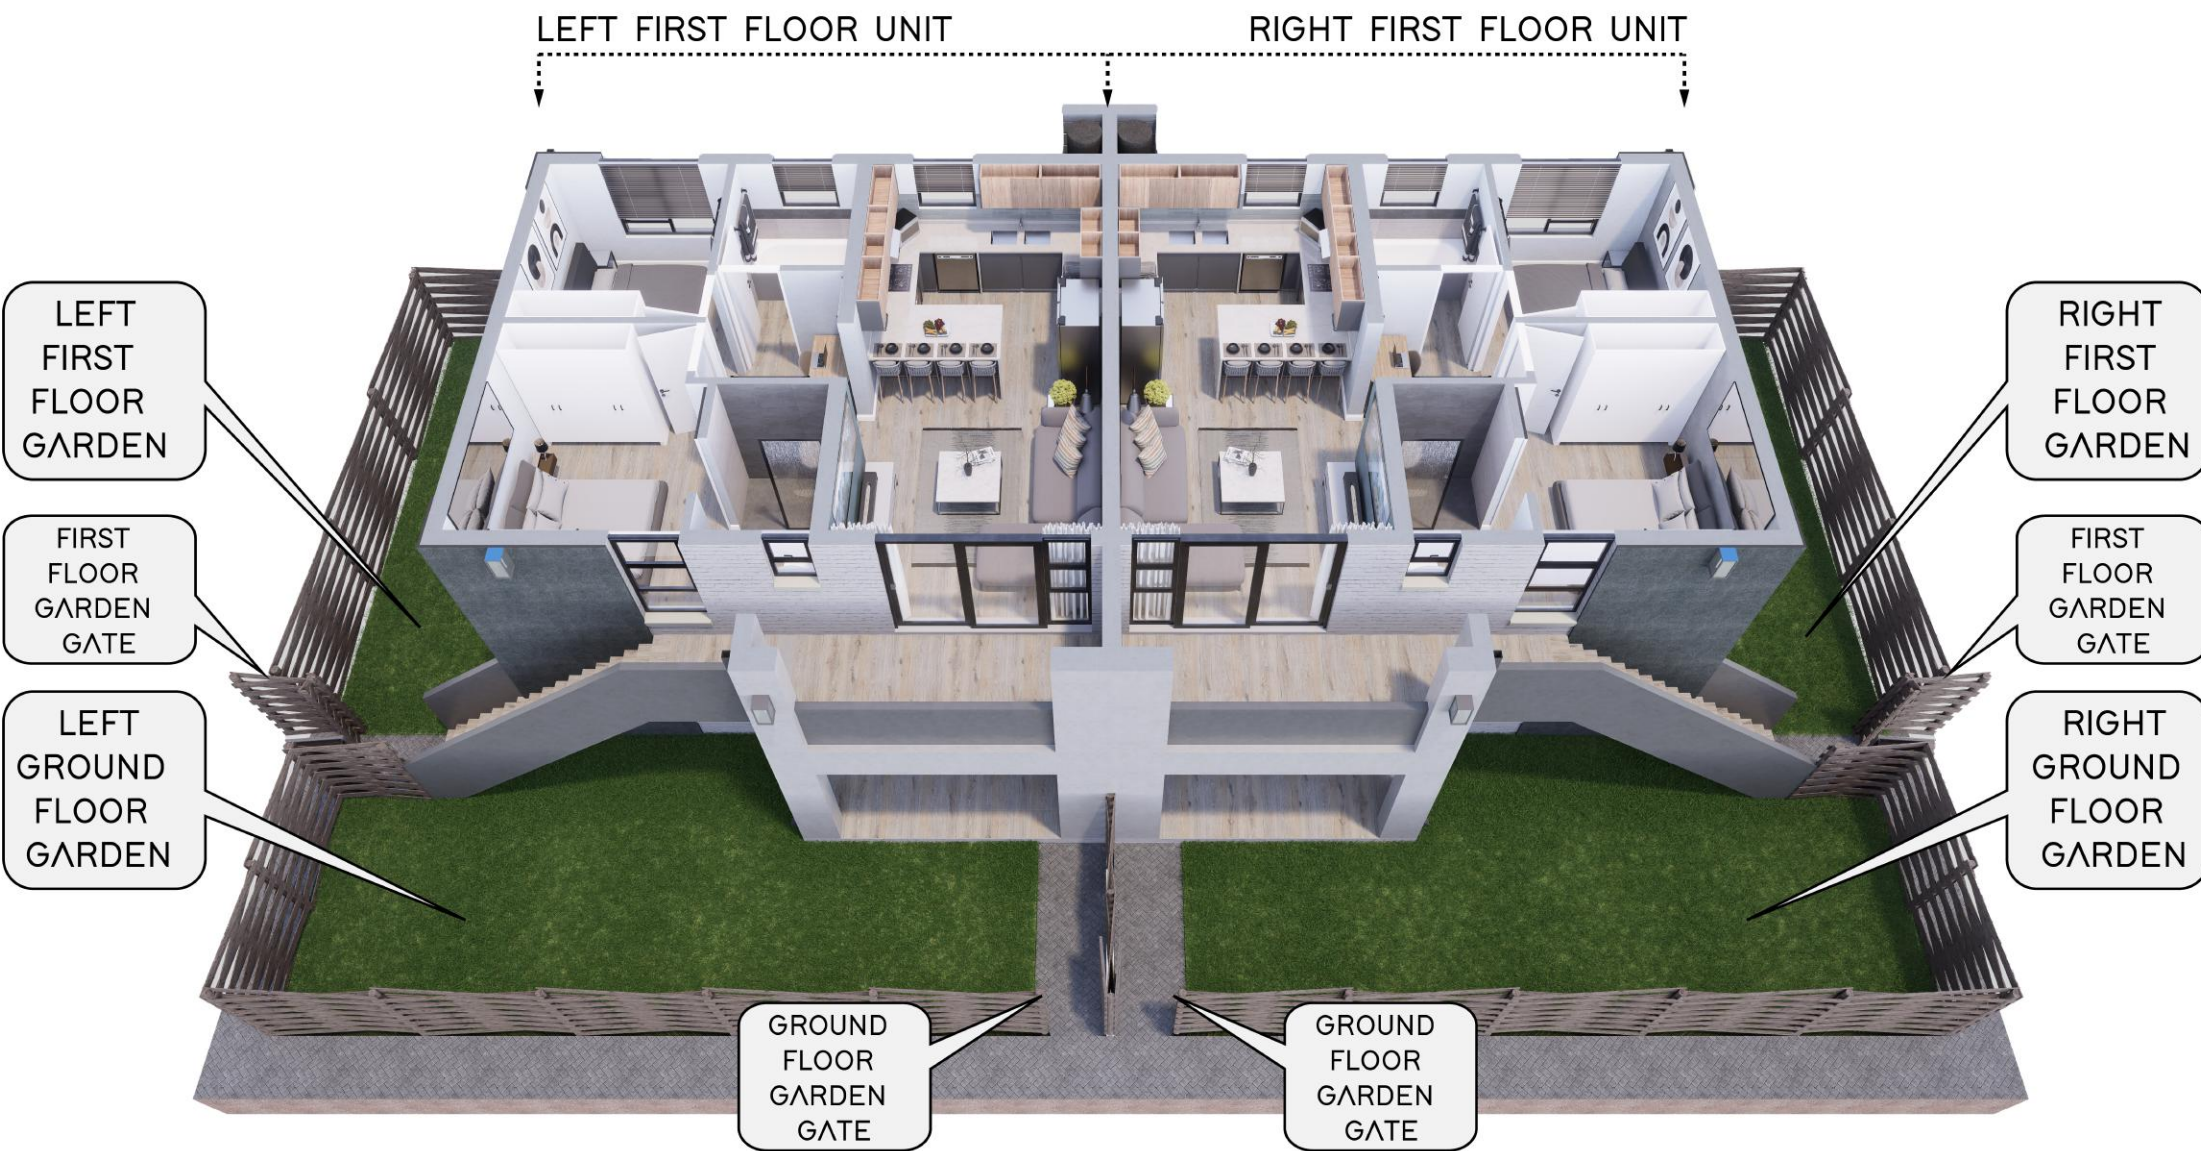


TYPE A - NORTH ENTRY - FIRST FLOOR

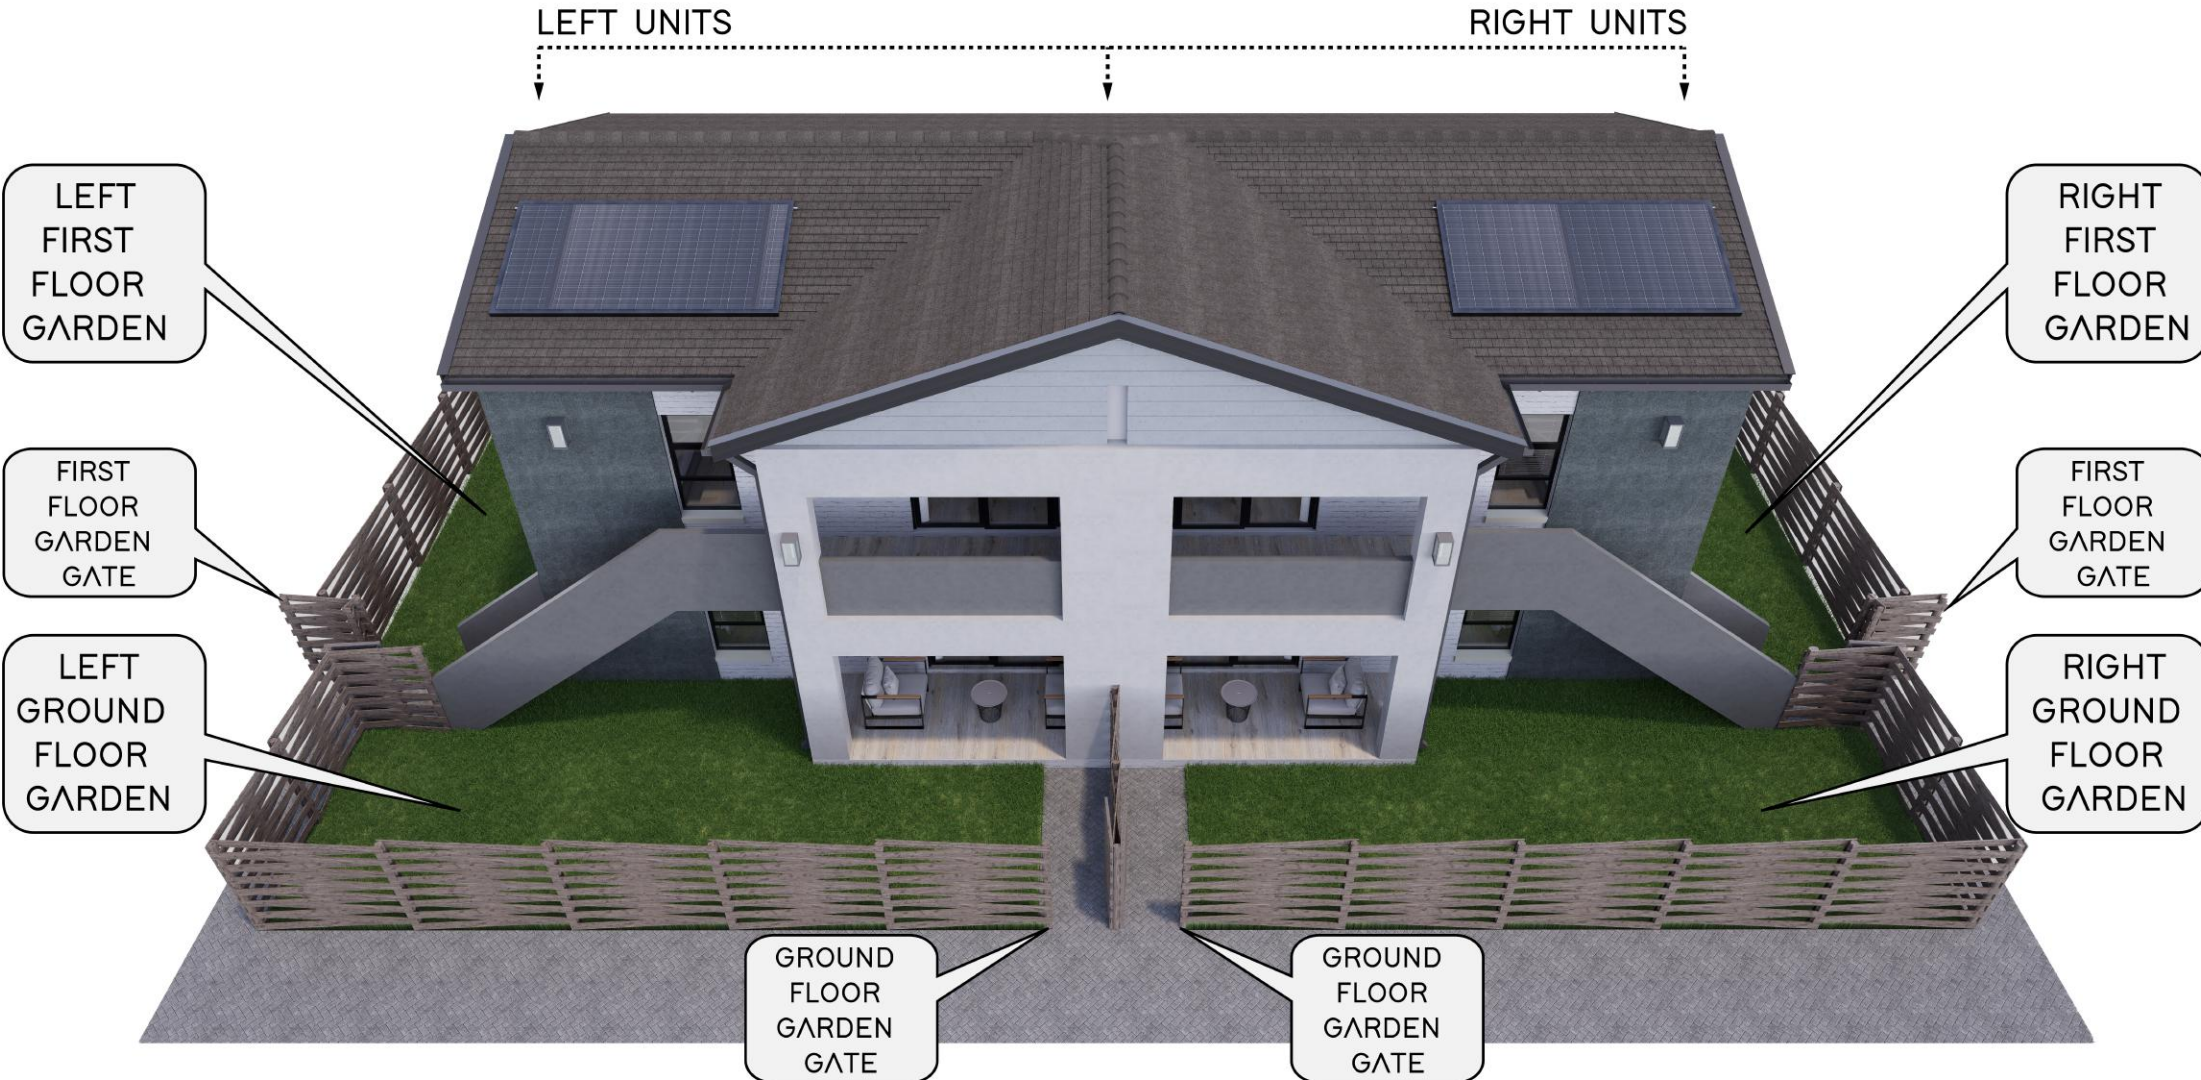

TYPE A - NORTH ENTRY

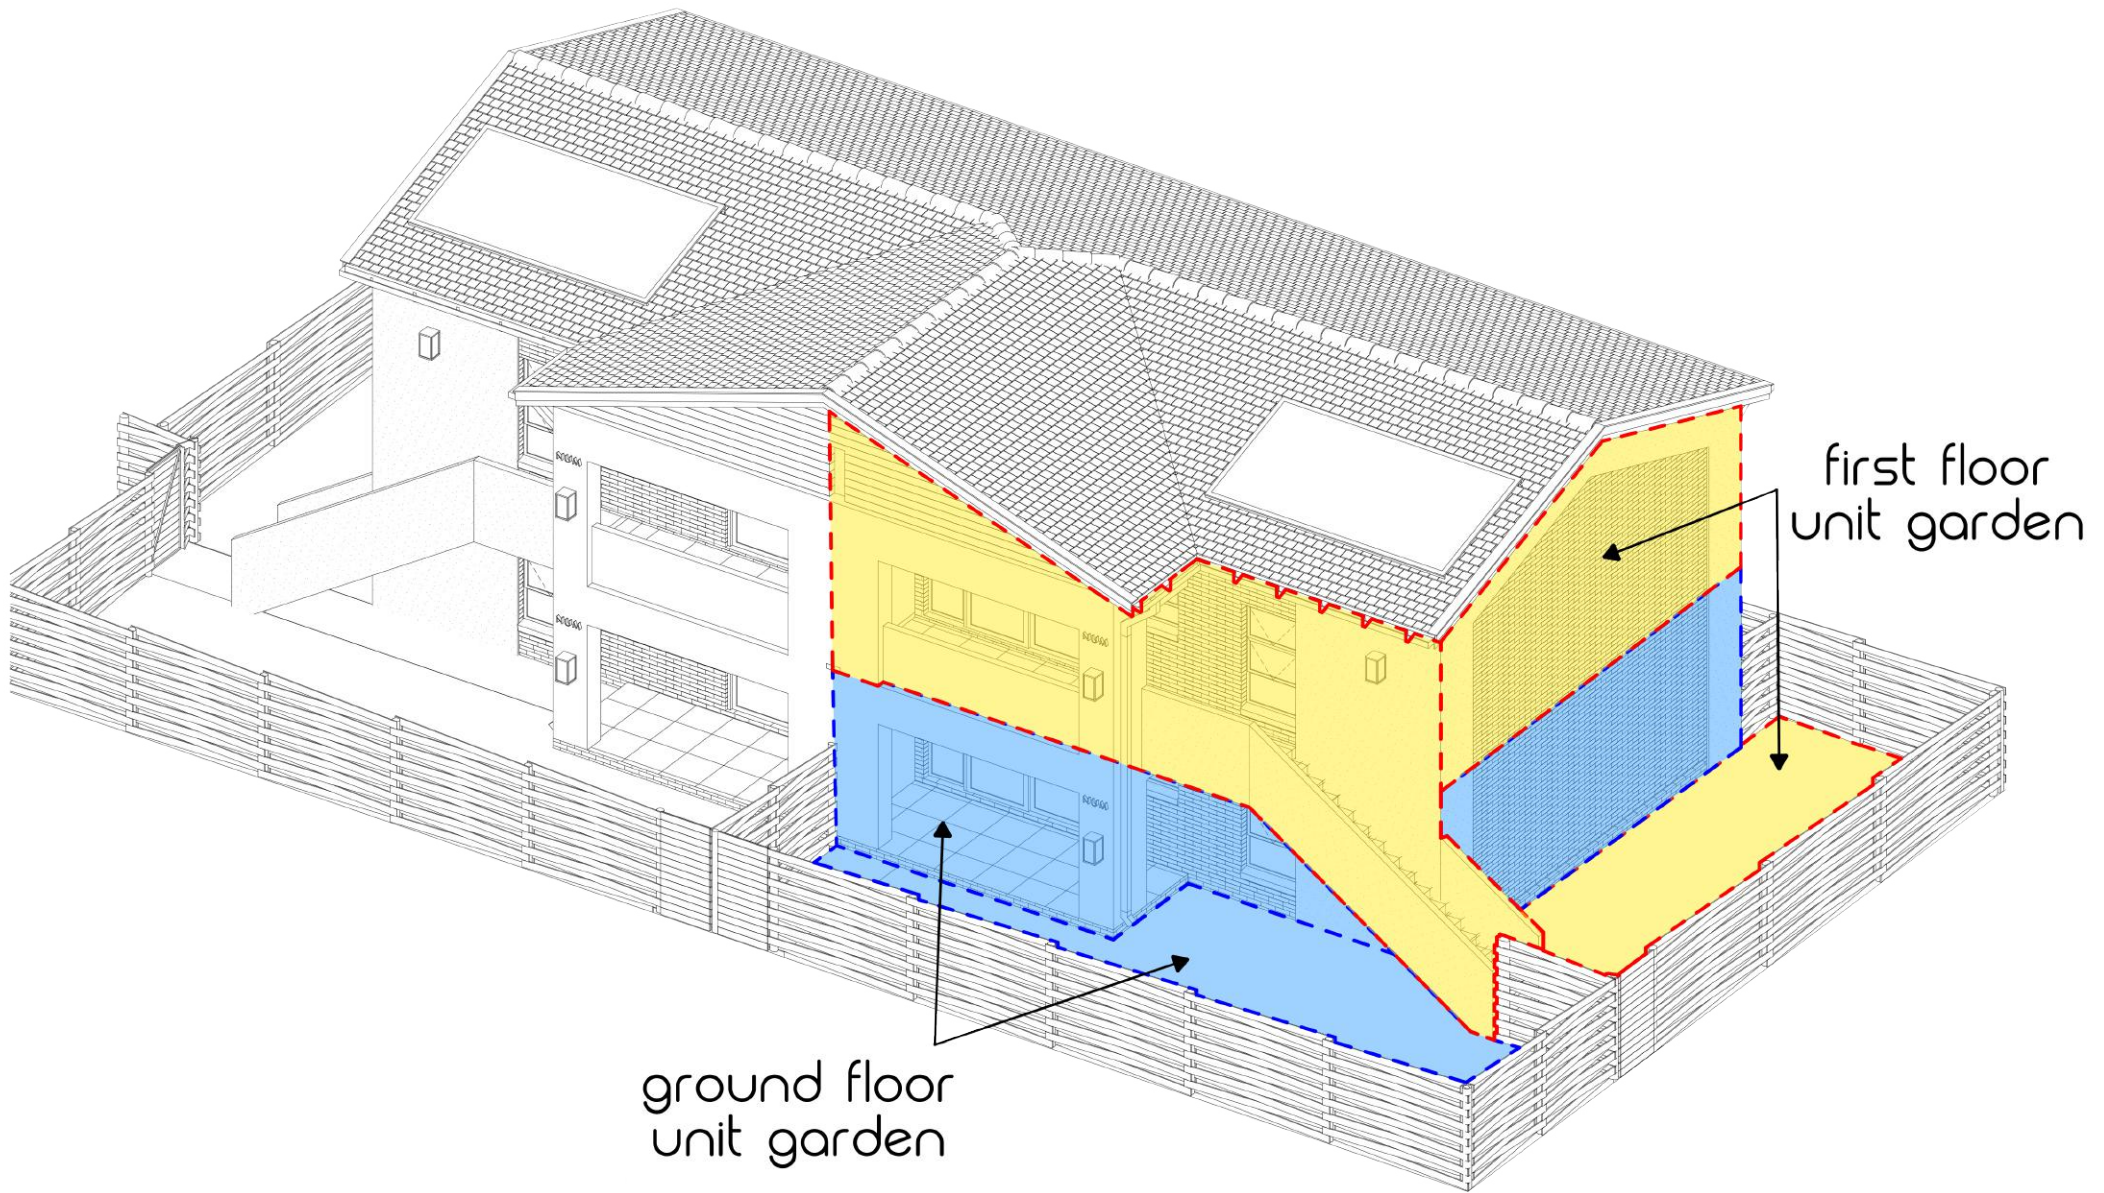


TYPE B - GROUND FLOOR

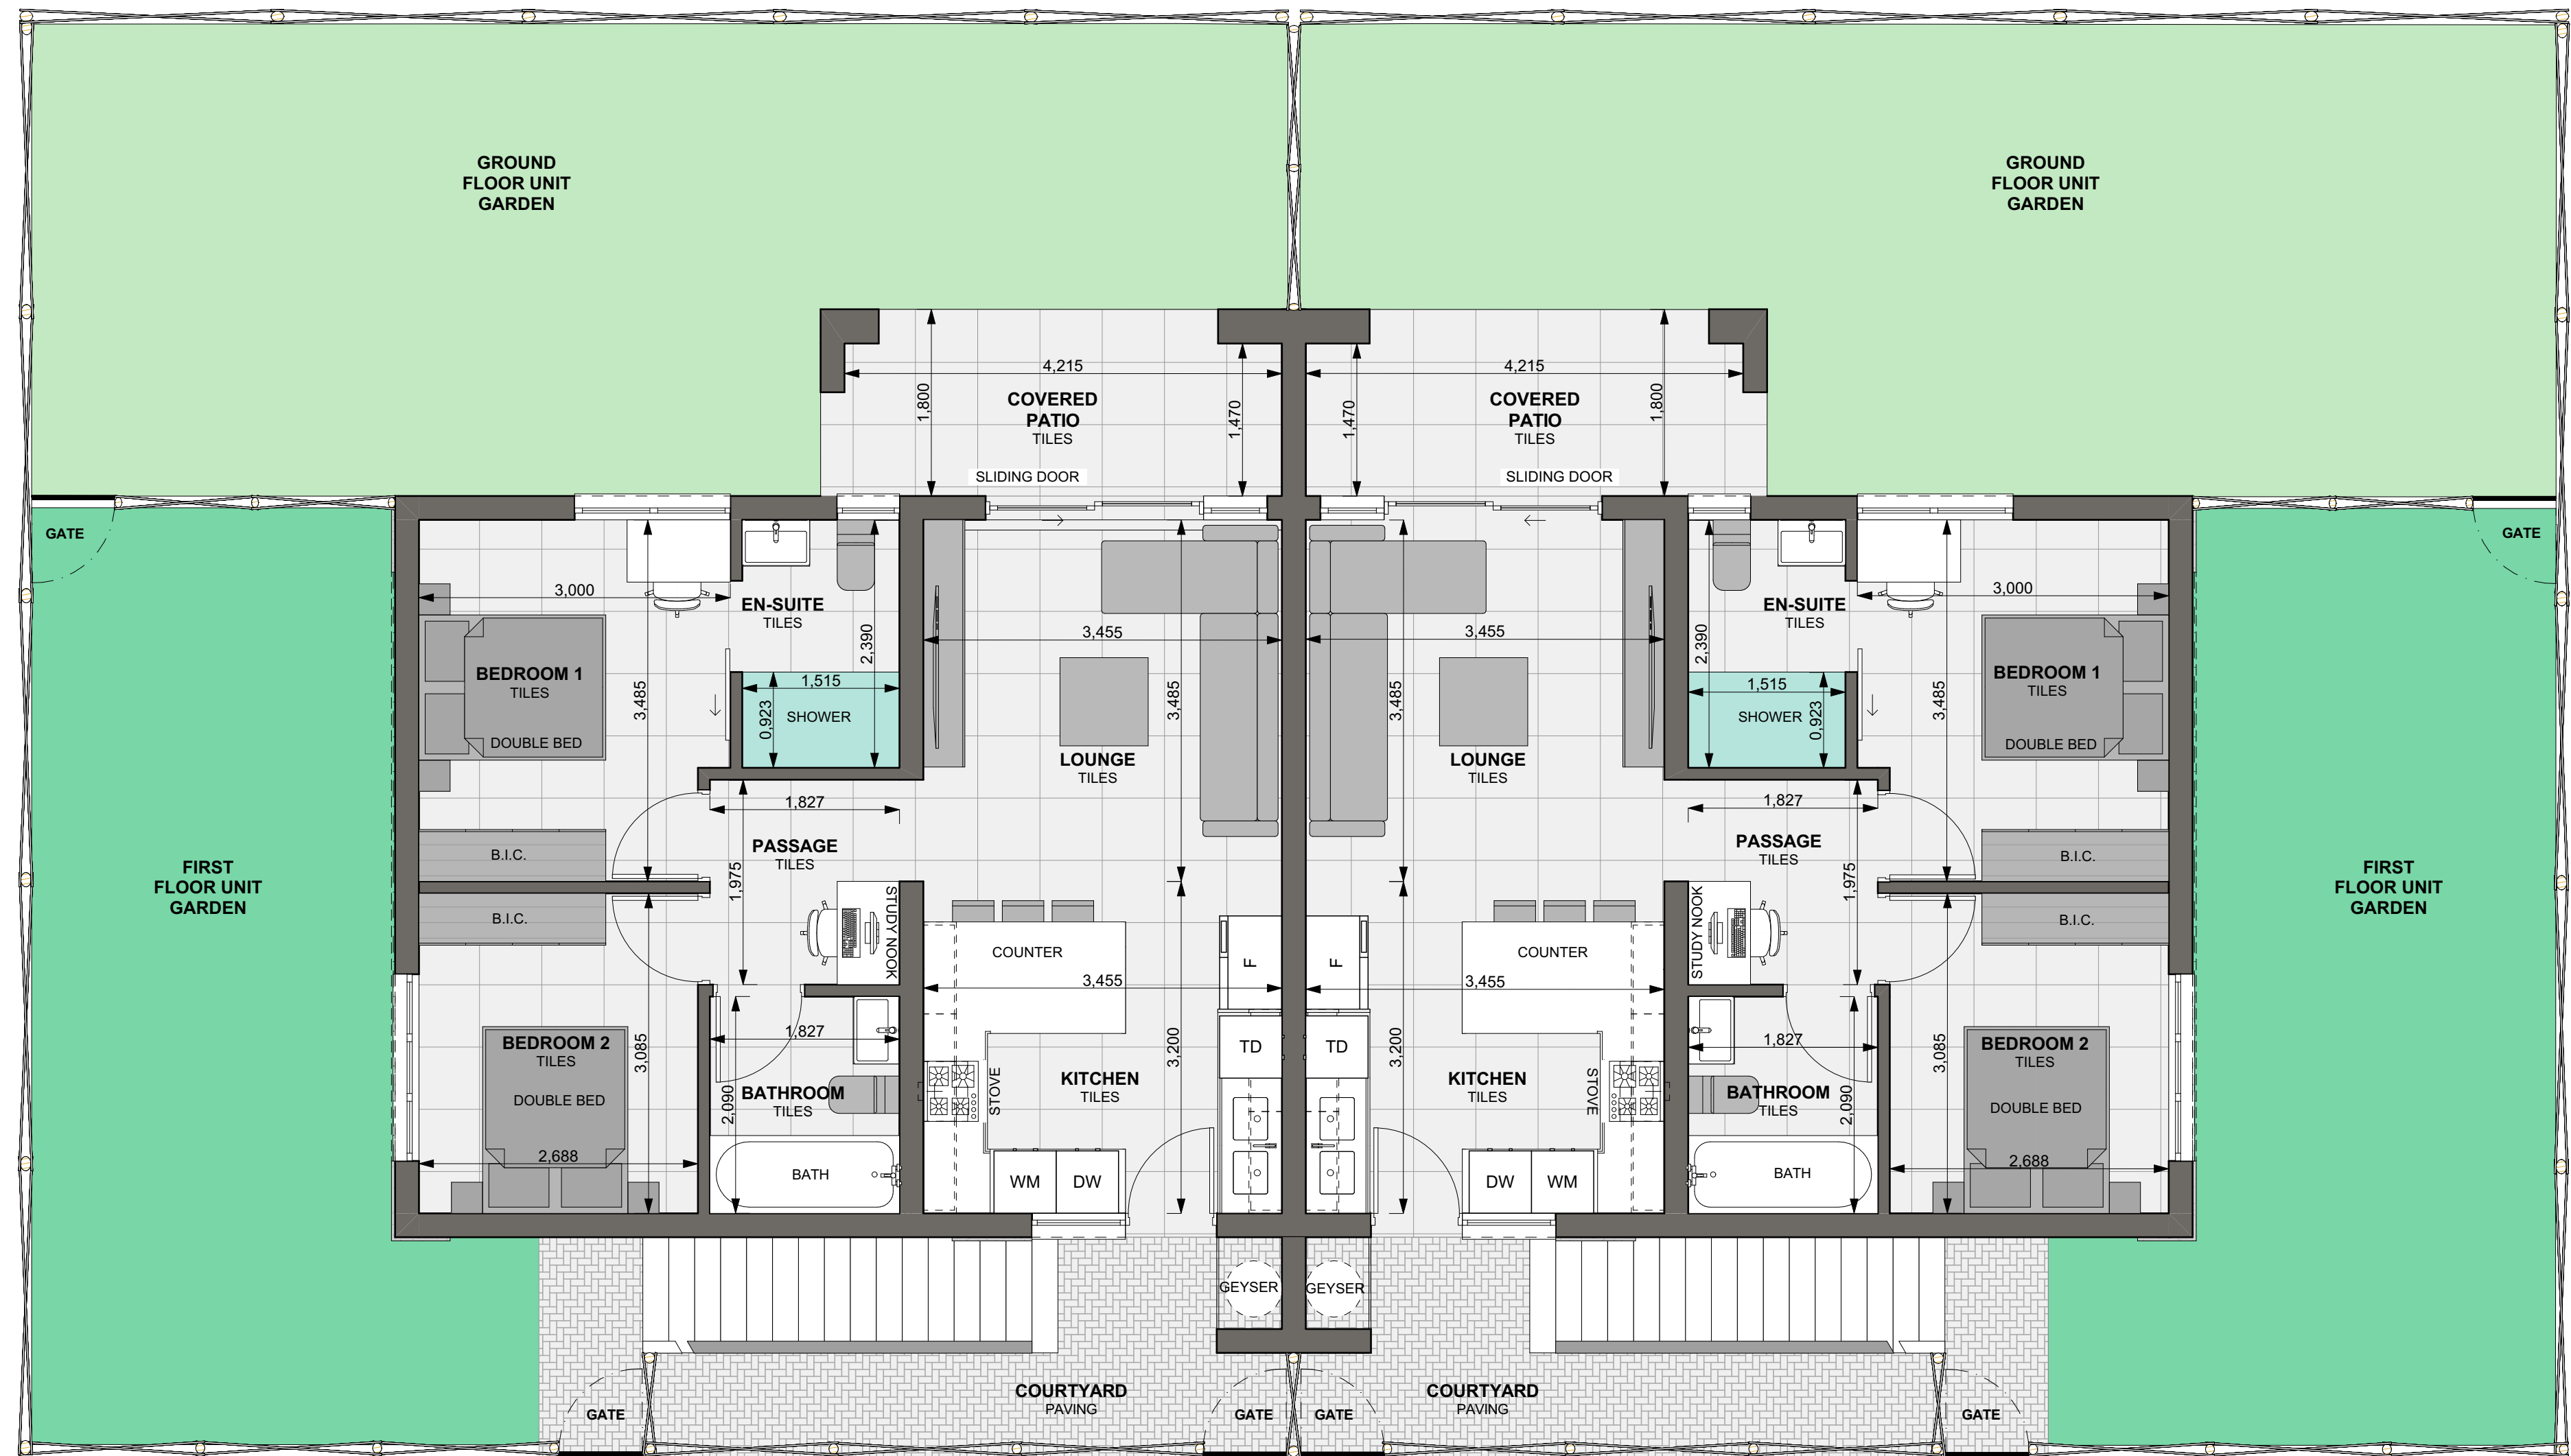

GROUND FLOOR
SCALE 1:50

TYPE B - SOUTH ENTRY

GROUND FLOOR: 61,88
PATIO: 8,21
70,09 m²

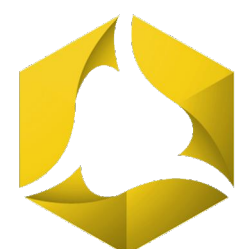


SSI
Group



VANRICK
ARCHITECTURE
WWW.VANRICK.CO.ZA


TYPE B - FIRST FLOOR

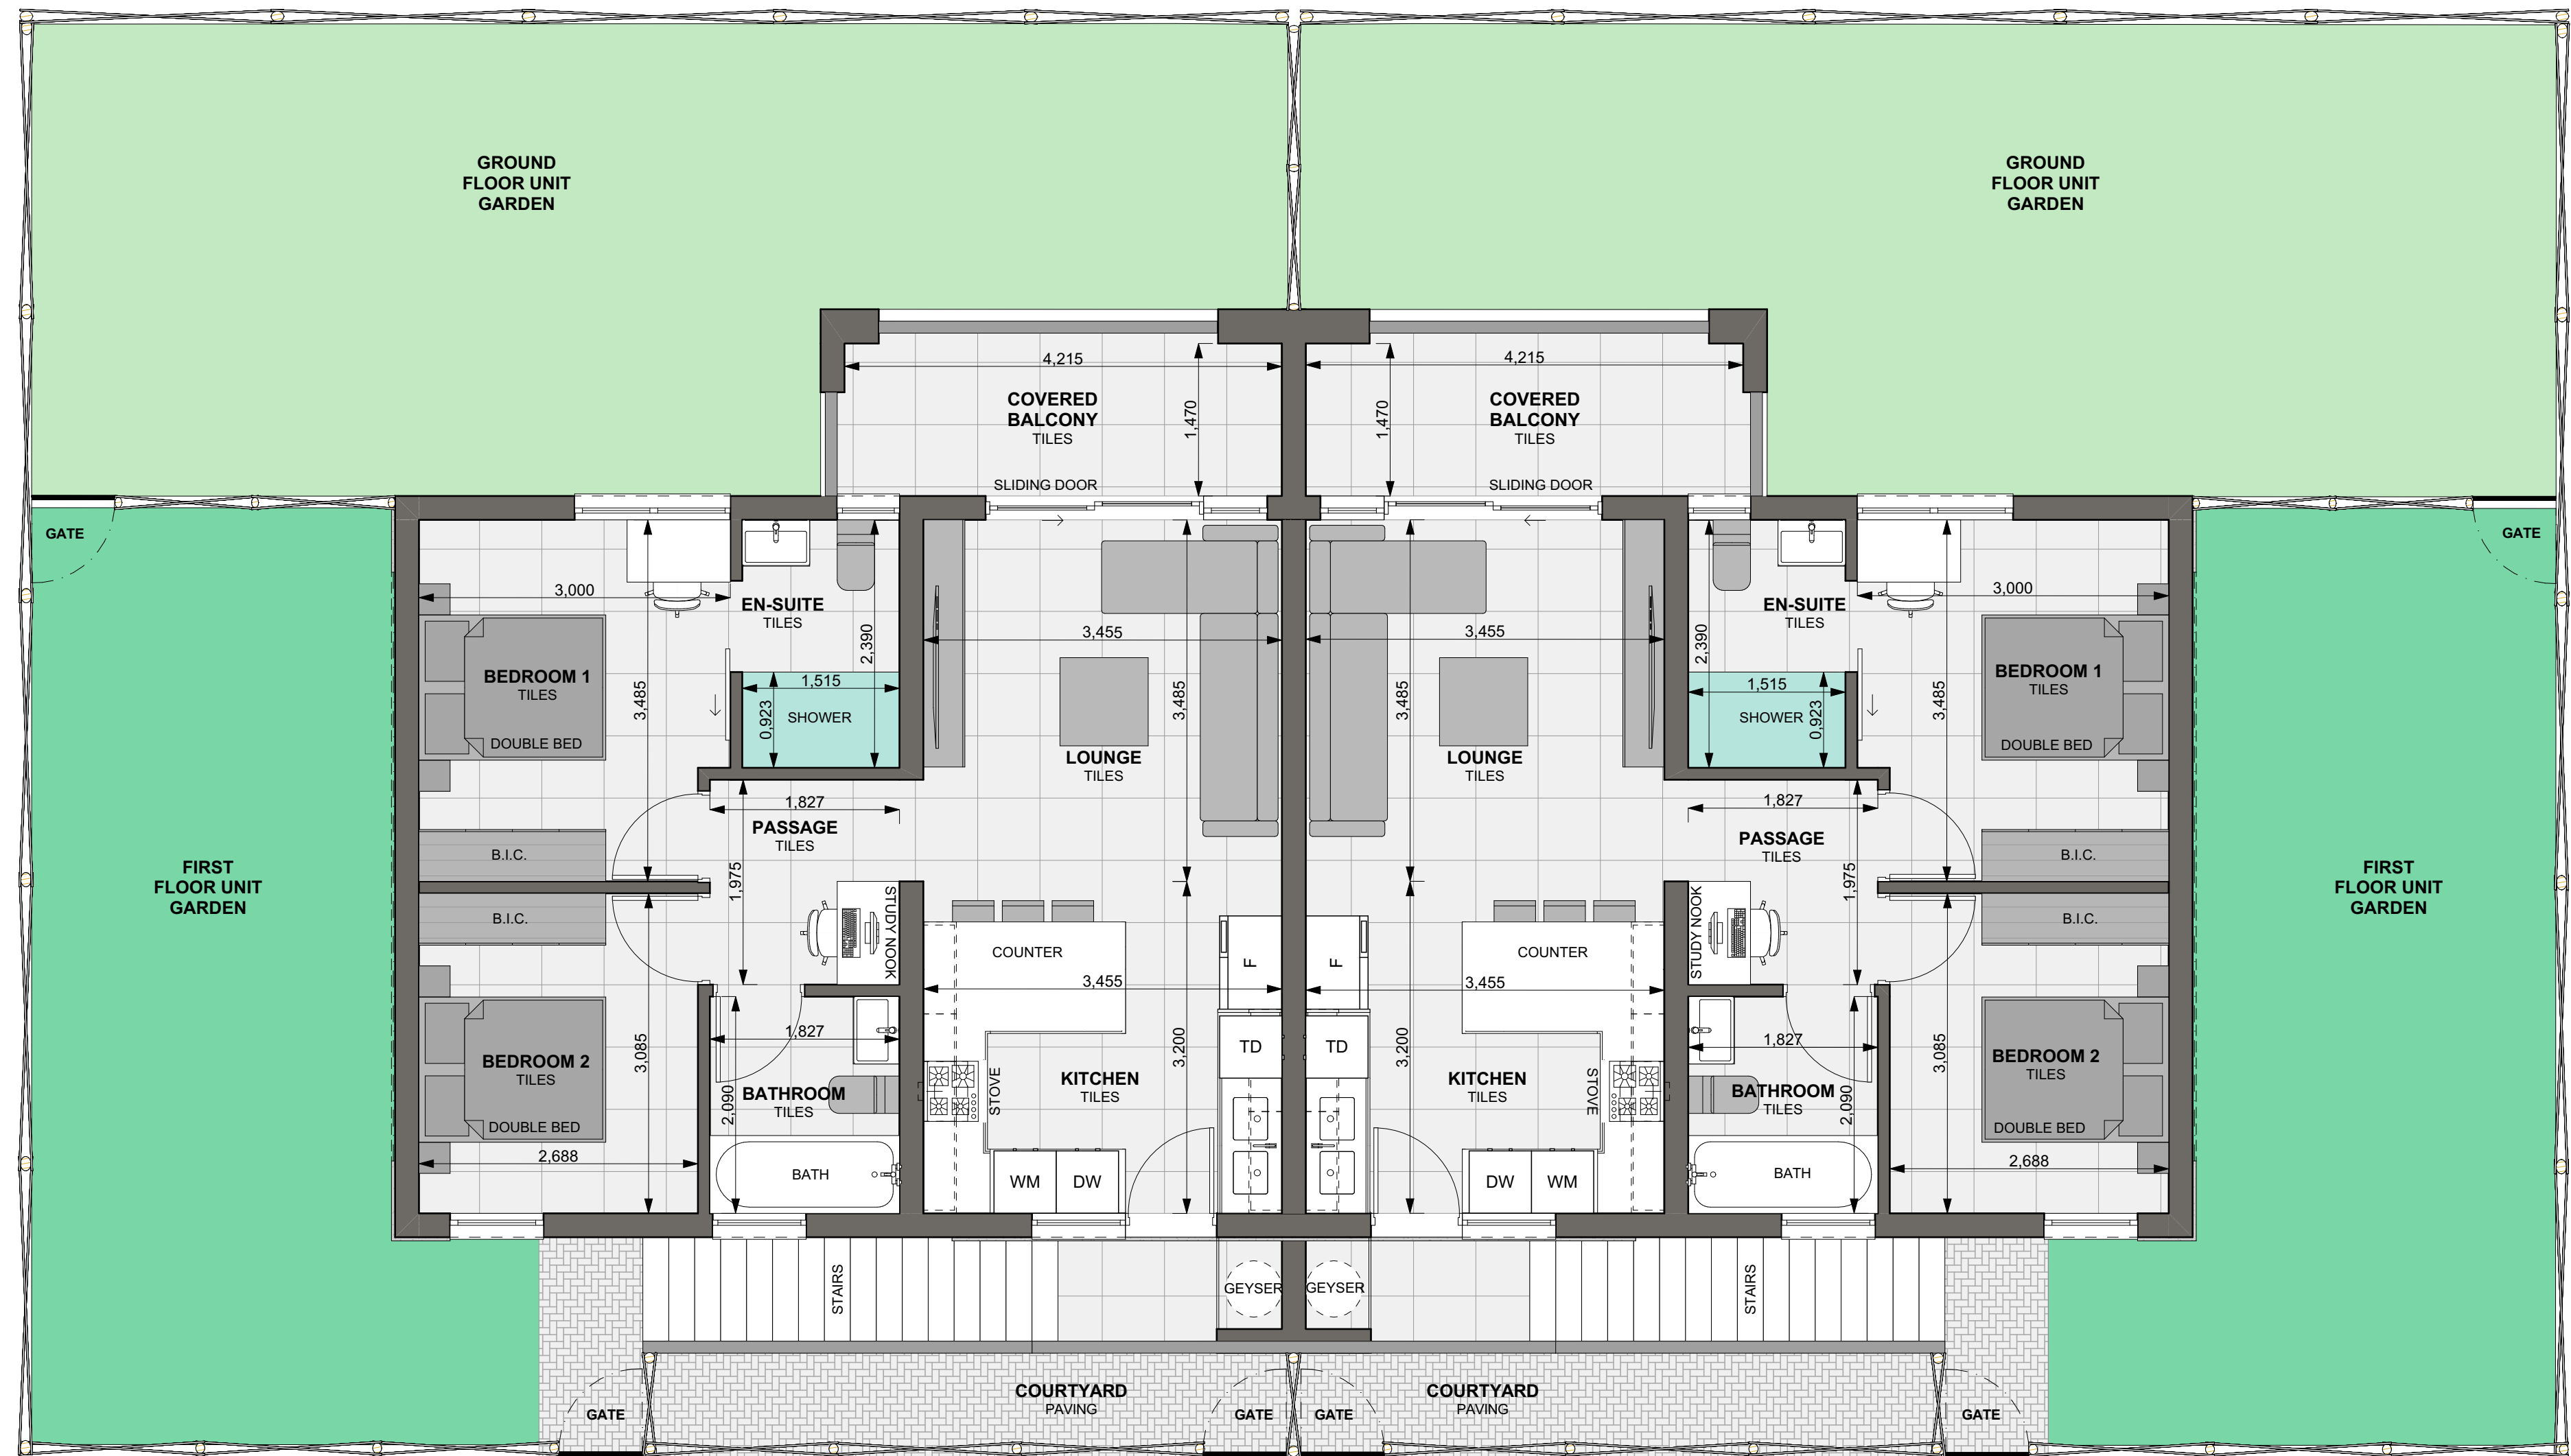

FIRST FLOOR
SCALE 1:50

TYPE B - SOUTH ENTRY


FIRST FLOOR: 61,88
BALCONY: 8,21
70,09 m²

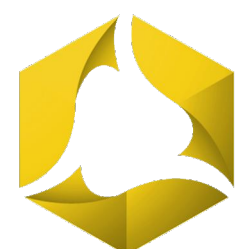


SSI
Group




VANRICK
ARCHITECTURE
WWW.VANRICK.CO.ZA

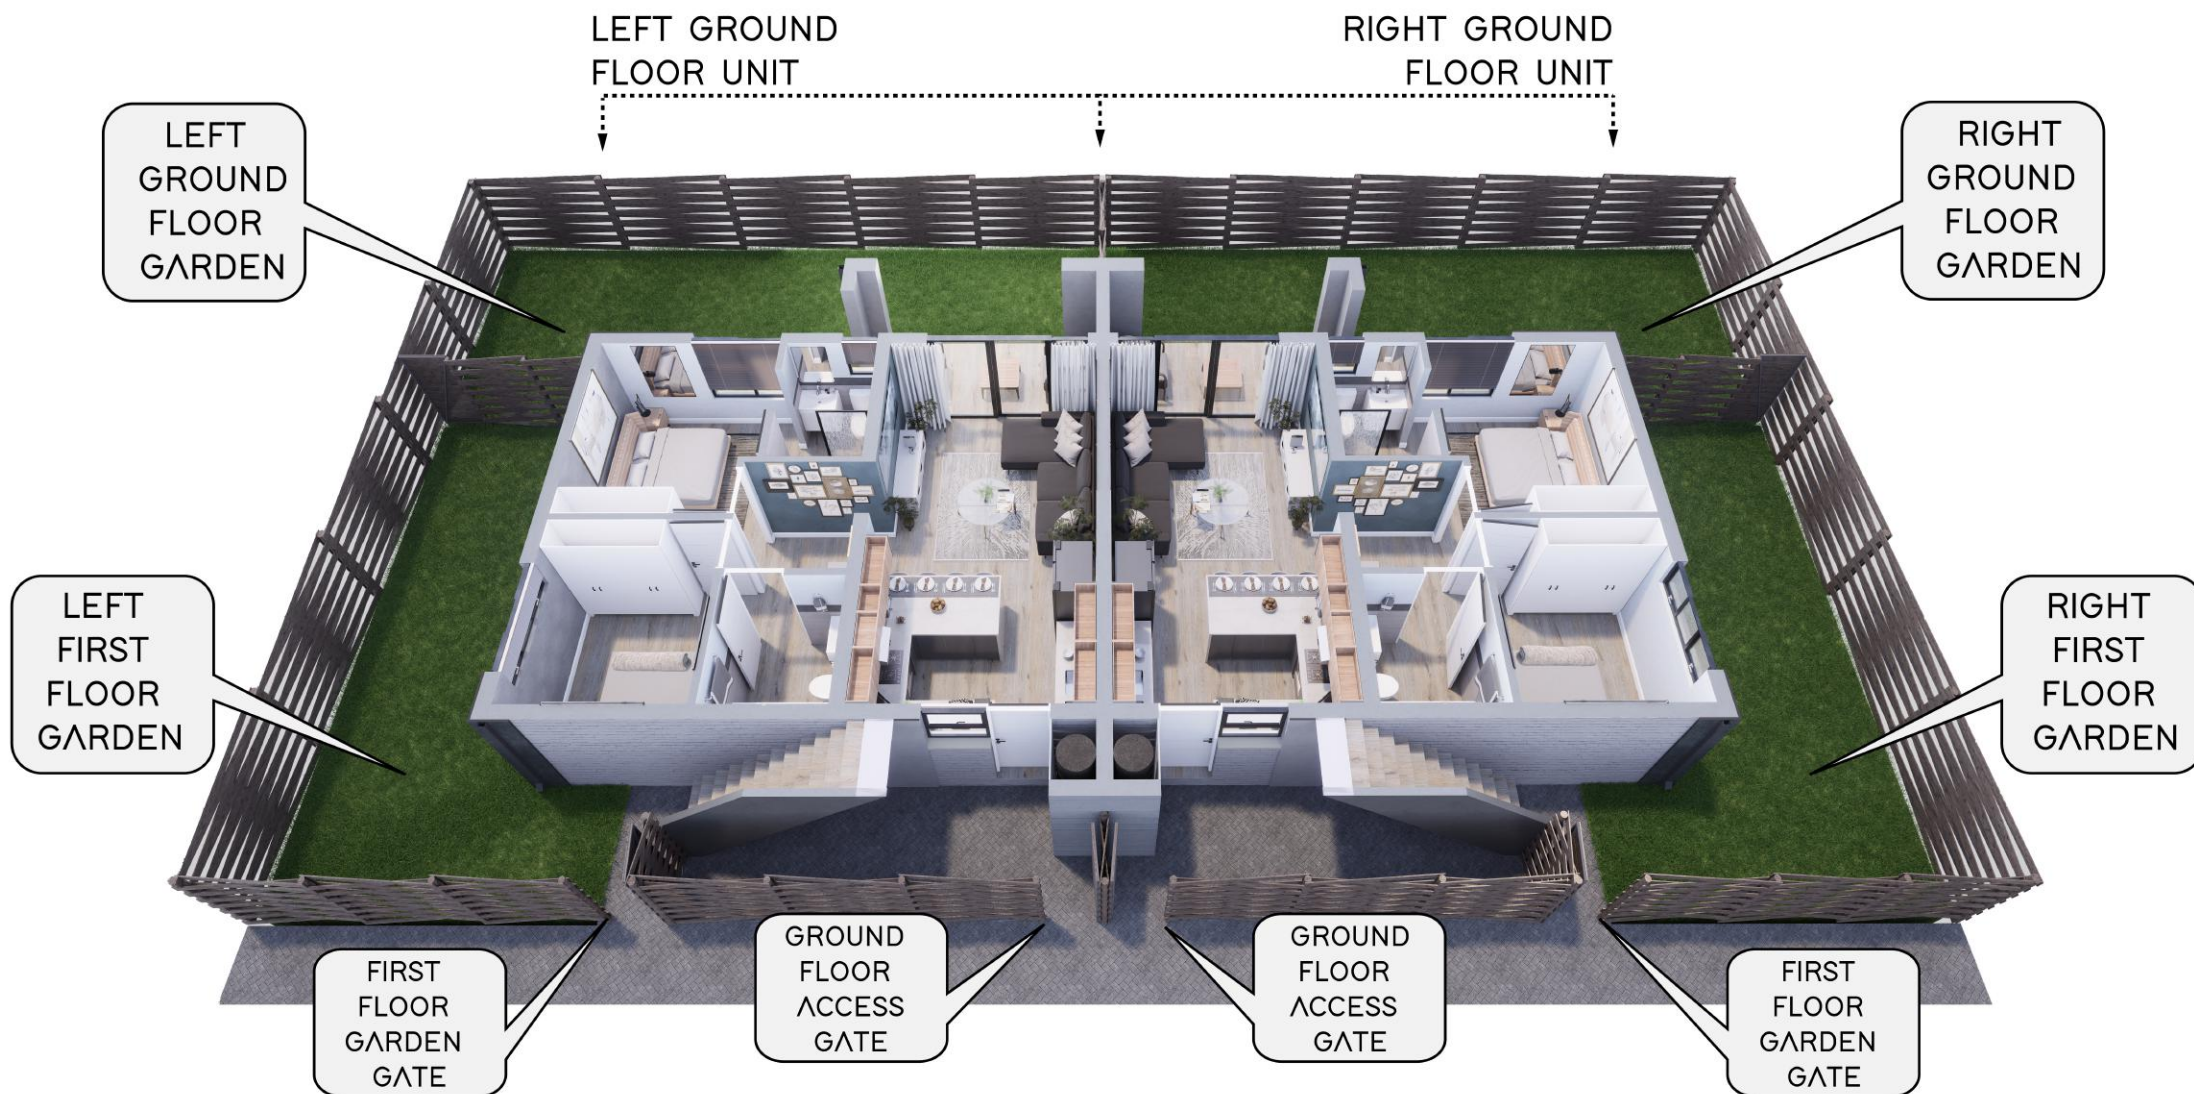


TYPE B - SOUTH ENTRY - GROUND FLOOR

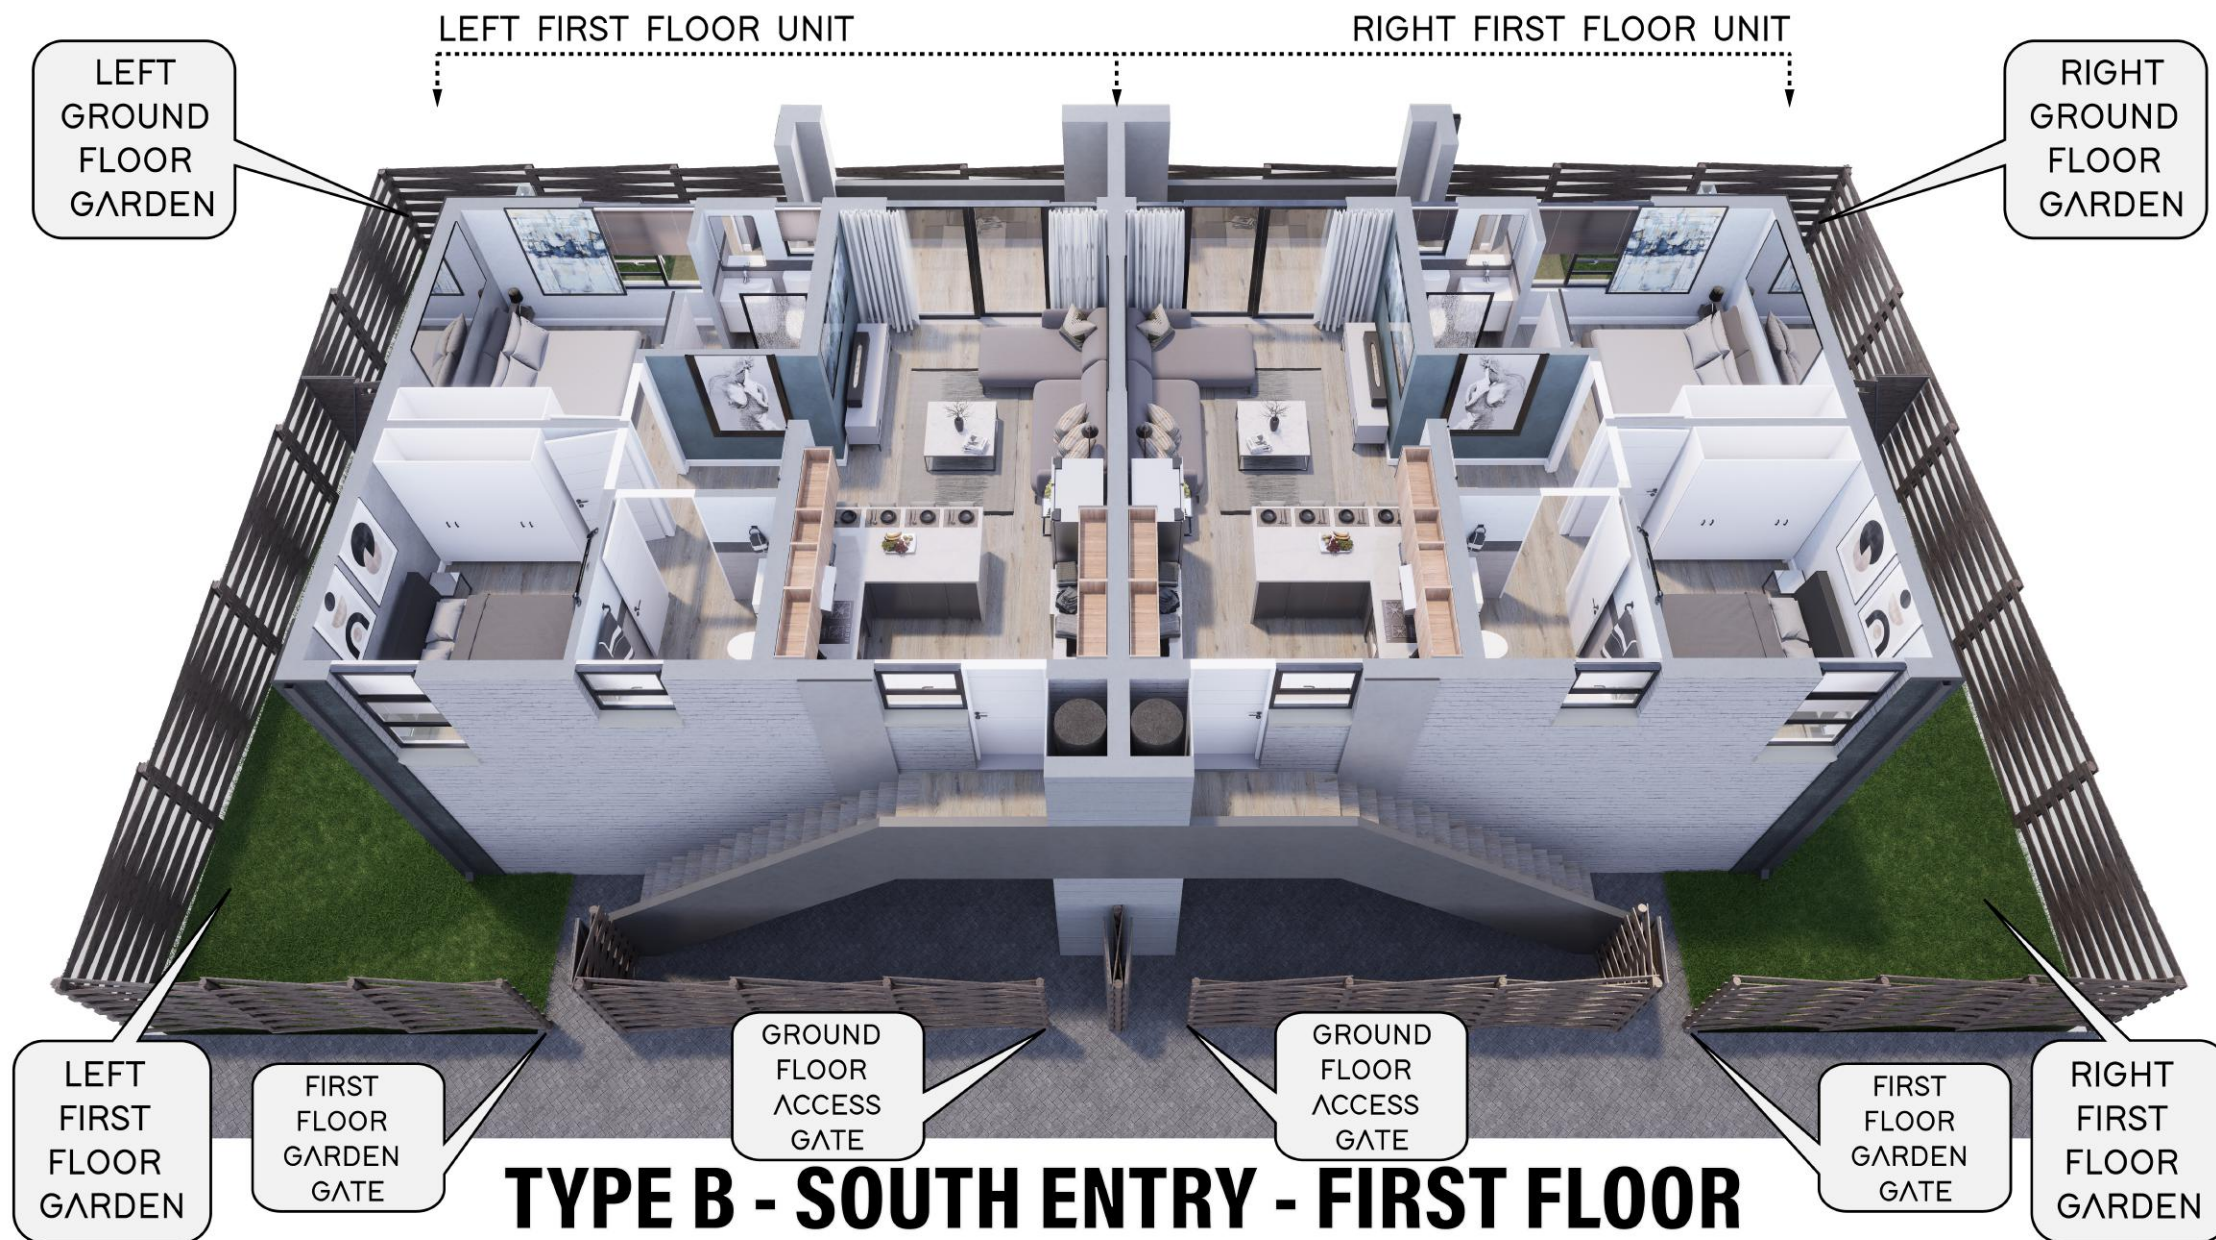

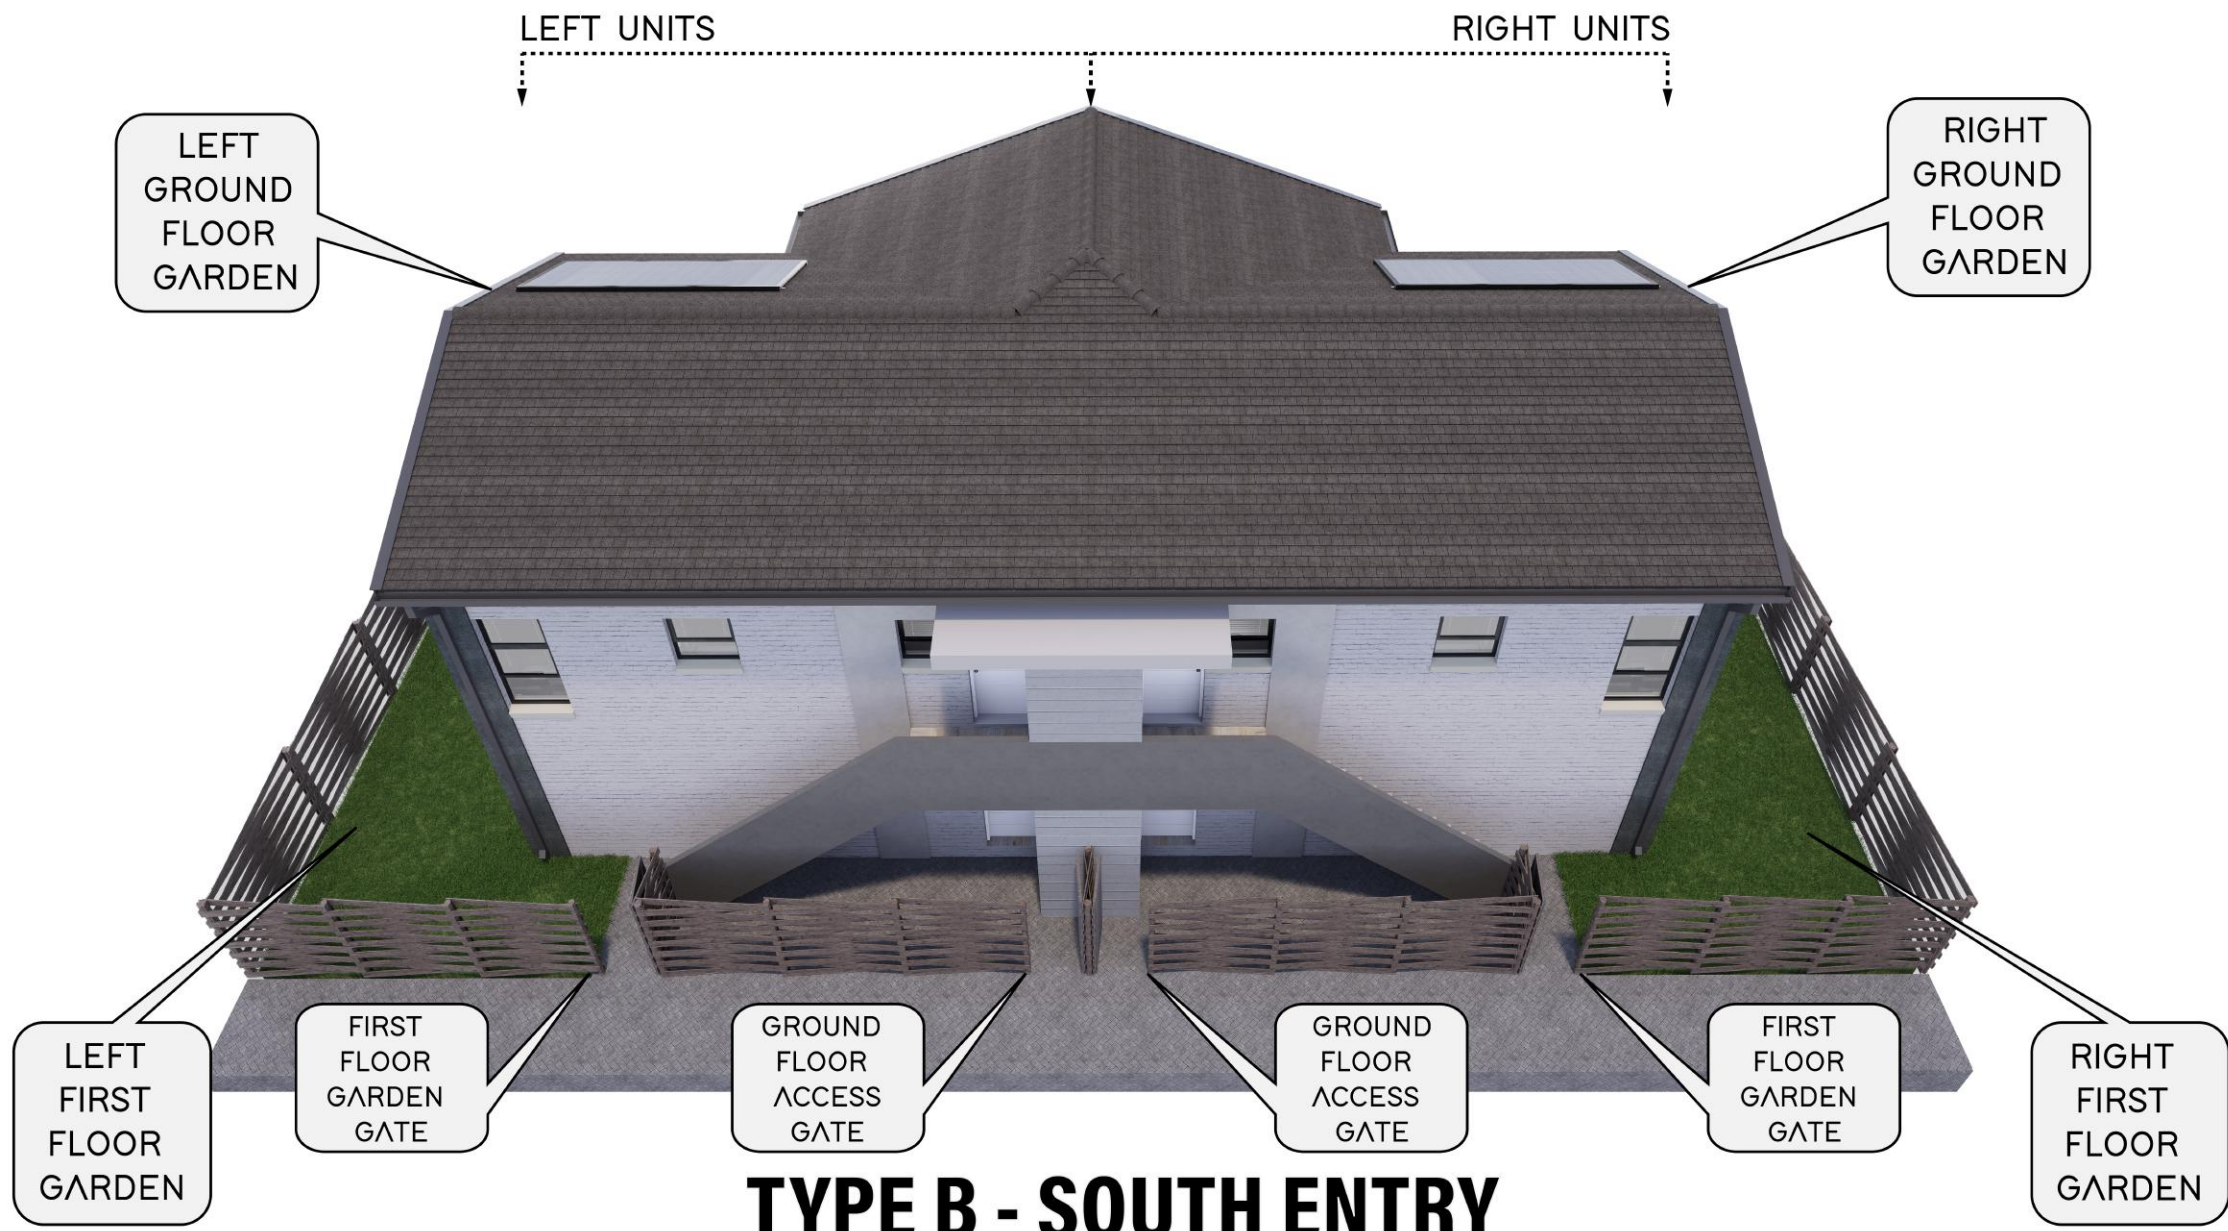

ground floor
unit garden

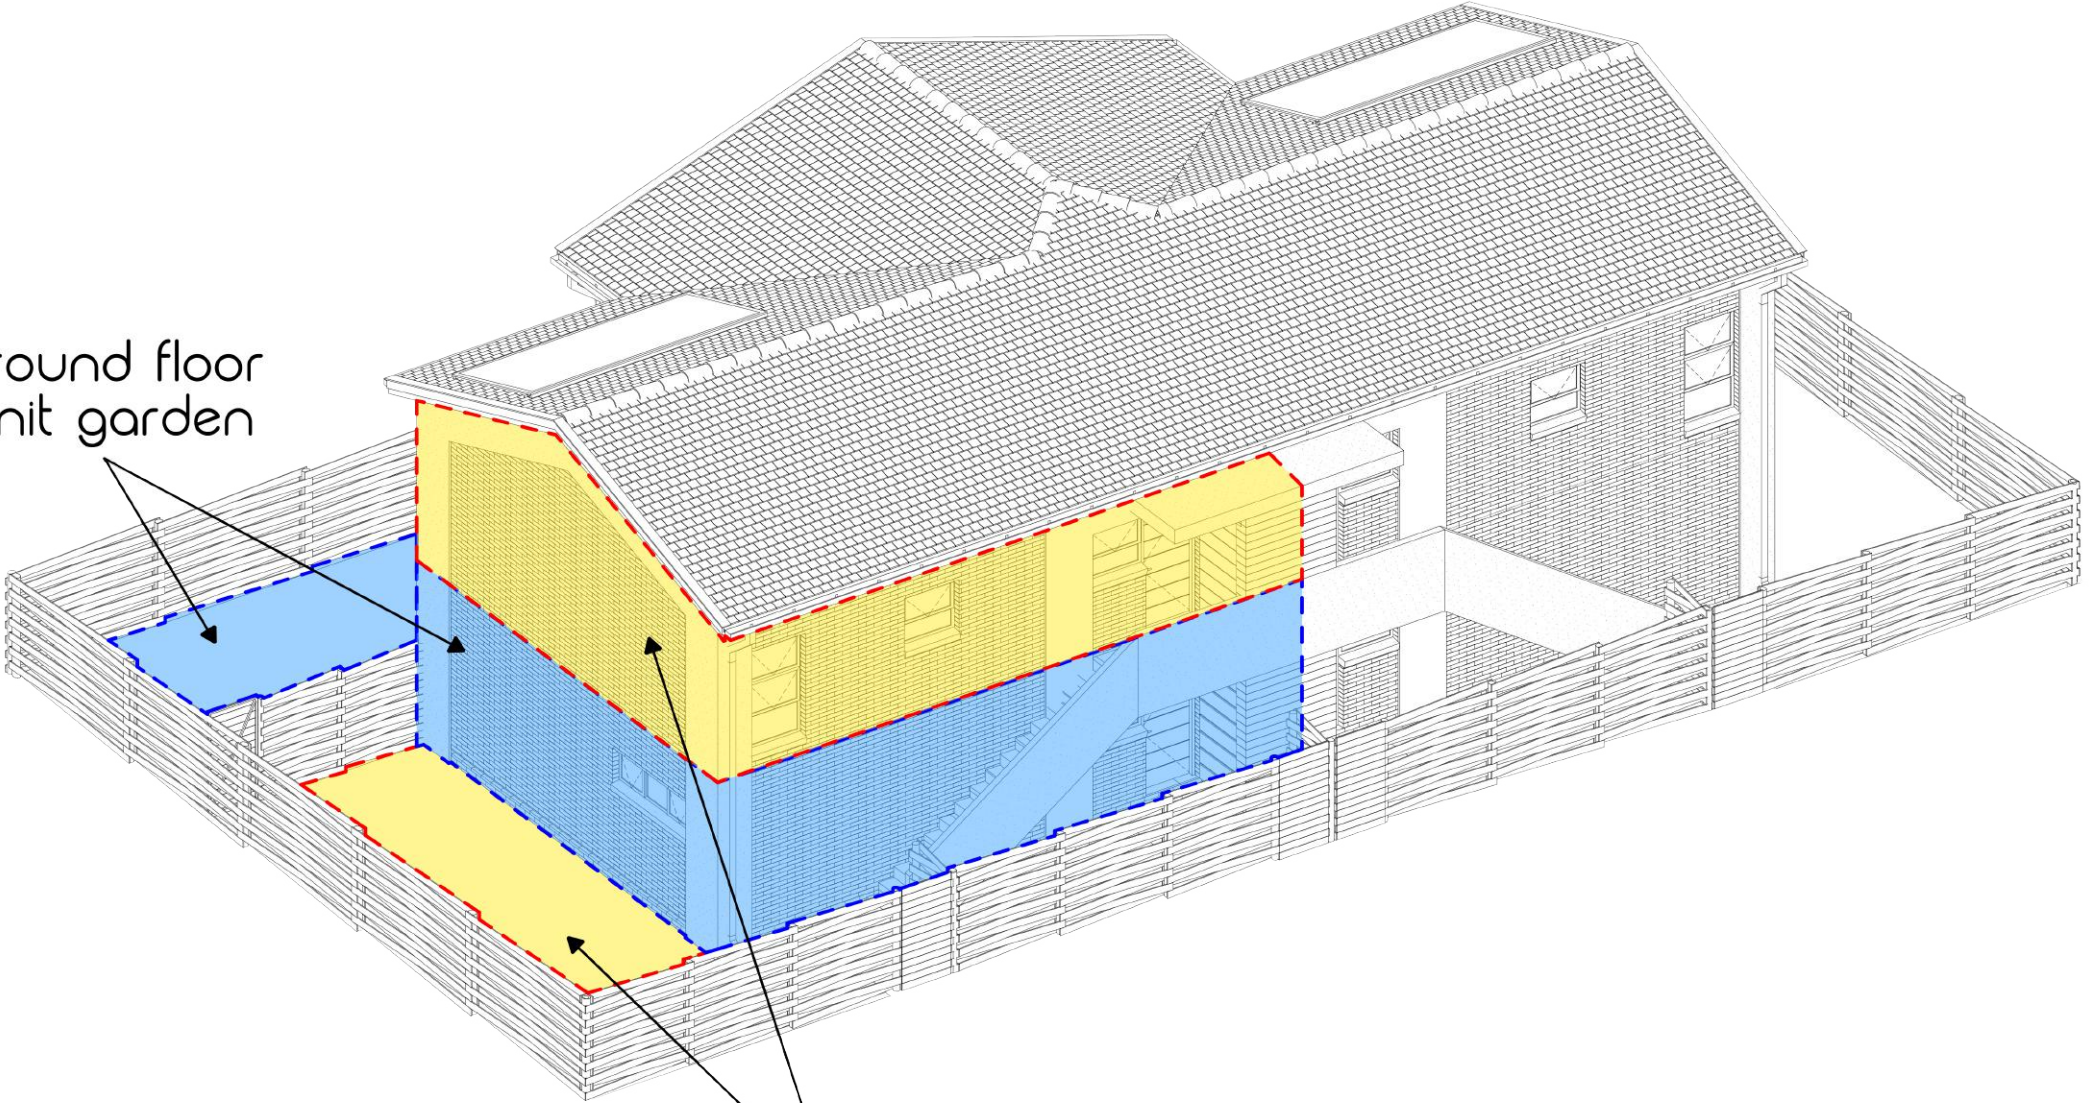

first floor
unit garden